


SB_1 - Plan View


1 : 50

Please note that pod setting out can vary slightly. Refer to GA plans for pod setting out reference (shape). To be used in conjunction with 1511_22_016

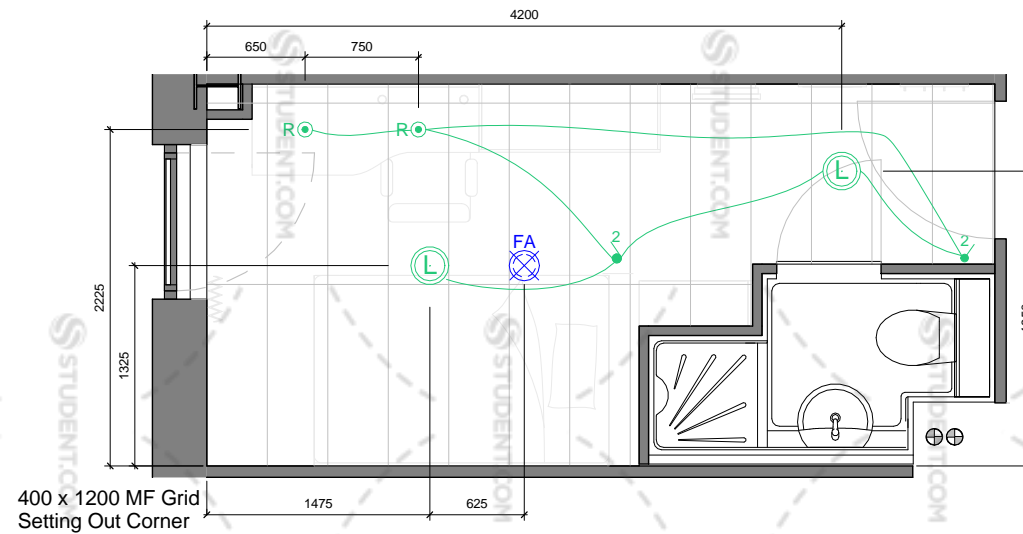

SB_1 - Reflected Ceiling Plan


1 : 50

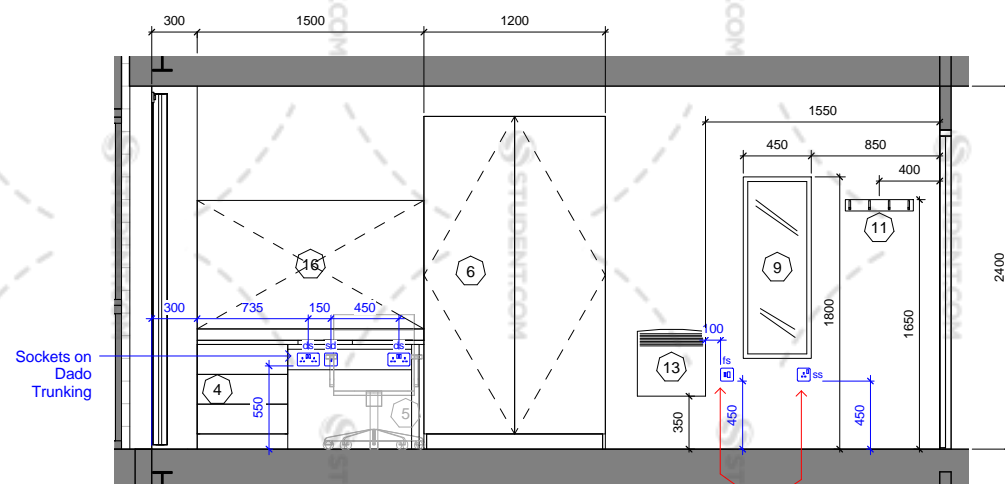

SB_1 - Elevation A

1 : 50


Sockets to be installed to right hand side at all times to avoid back to back sockets.

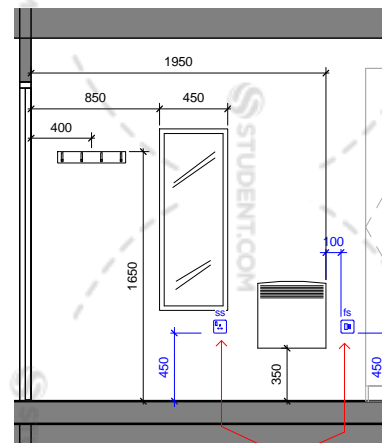

SB_1 - Elevation A (Mirror)


1 : 50

Sockets to be installed to right hand side at all times to avoid back to back sockets.

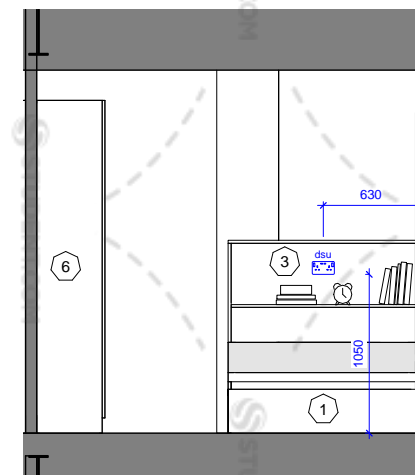


SB_1 - Elevation B

1 : 50

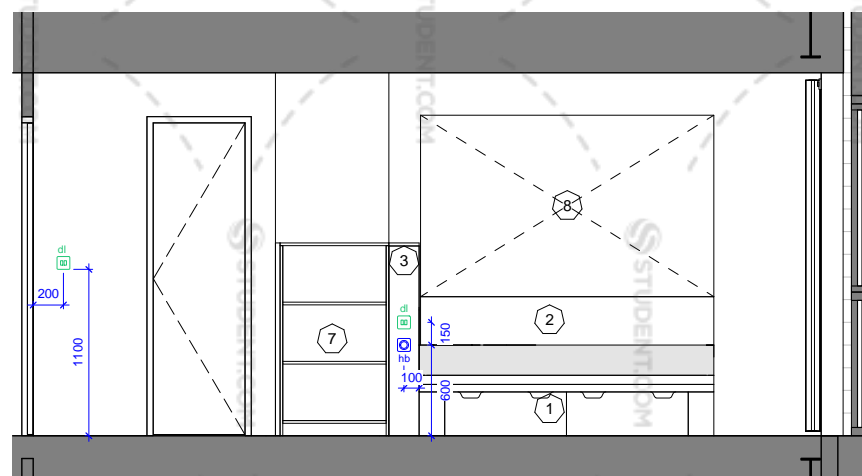


SB_1 - Elevation C

1 : 50

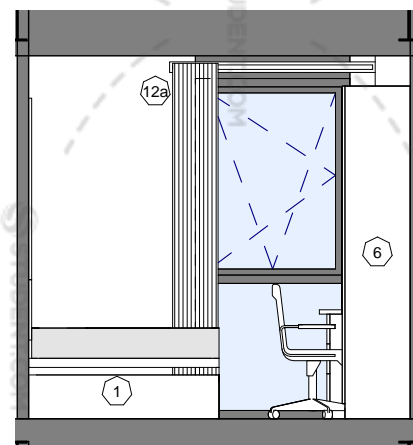


SB_1 - Elevation D

1 : 50

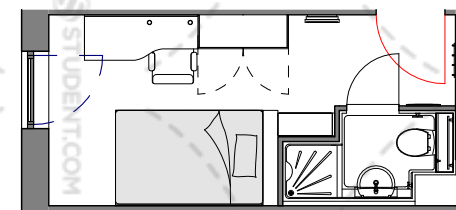

Refer to 72_020 For rooms with alternative door location

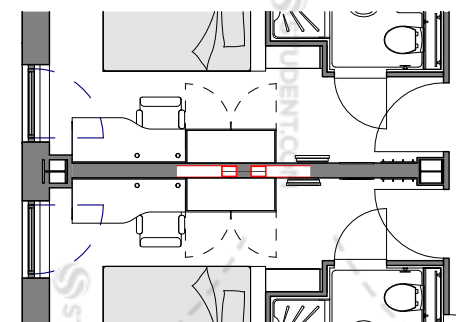

Refer to 72_021 For rooms next to steel bracing

notes:

All dimensions are in millimetres unless stated otherwise. No dimensions to be scaled from drawings. All dimensions to be checked on site prior to manufacture.

Any discrepancies between drawings and site conditions are to be reported to the contract manager.

This drawing is to be read in conjunction with all relevant Structural Engineers and Mechanical & Electrical Engineers drawings and specification.

Copyright of this drawing and all the information it contains is the sole property of OEA and may not be reproduced or used for any purpose without the written approval of the authors

SB_1 - Schedule

No.	Description	Count
1	Cabin Bed	1
2	Long Side Wall Protector	1
3	Bed-head Shelf Storage Unit	1
4	Scalloped Desk with Drawer Unit Undereath	1
5	Operators Chair with Arms	1
6	Double Wardrobe - Refer to Matrix	1
7	Floor Mounted Bookcase	1
8	Pinboard (Above Bed)	1
9	Framed Mirror	1
11	4 Coat Hooks Mounted on Wall Plate	1
12a	Fire Retardant Curtains (Single) on RAL 9010 PVC Track	1
13	Heater to M&E Specification	1
16	Pinboard (Above Desk)	1

Walls to be framed out for electrics to remove penetrations from air seal line

ELECTRICAL SYMBOL KEY

ss	- Single Socket	tv	- TV Aerial
ds	- Double Socket	fs	- Fused Spur
dsu	- Double Socket with USB charging socket	ha	- Hob Angel Timer
sd	- Single Data (RJ45)	hb	- Heater Booster
dd	- Double Data (RJ45)	eb	- Extract Boost
sl	- Single Light Switch (1 gang)	L	- Bulkhead LED Light to M&E Spec.
dl	- Double Light Switch (2 gang)	R	- Recessed LED Light to M&E Spec.
cc	- Cooker wire connection	P	- PIR Sensor
is	- Cooker / Hob isolation switch	FA	- Fire Alarm Sounder & Detector to M&E Spec.
		AH	- Access Hatch

- Electrical sockets and lighting shown for coordination purposes only.
- Lighting to M&E Sub-contractors design to meet RDS lux levels.
- Please refer to M&E sub-contractors drawings for final positions.
- All drawings to be confirmed by Sub-contractor's before manufacture
- All Radiator positions to be confirmed by M&E Sub-contractor

dwg status:

CONSTRUCTION

Rev	Description	Date	By	Chk
N	Additional drawing references added.	23/09/16	AP	
M	Curtain type revised. Pod setting out note added.	15/09/16	AP	
L	Furniture revised to Wessex drawings. Construction Issue.	15/08/16	AP	
K	Ceiling grid and lighting loop altered to suit client comments.	02/08/16	IW	AP
J	Bedhead sockets added, FS moved to Low level, RHS to match M&E.	04/07/16	IW	AP
H	Additional set-out information to sockets and switches added.	09/05/16	IR	PO
G	Heater repositioned (switched with mirror). Wardrobe size increased. Lighting loop added.	01/04/16	IW	AP
F	Heater repositioned from external wall. RCP revised to match M&E S.C. dwgs. Dimensions added.	15/01/16	GM	
E	General revision.	28/09/15	AP	
D	TENDER ISSUE.	22/05/15	AP	
C	Electrical socket key added	18/05/15	AP	
B	Revised to suit Client's comments	14/05/15	AP	
A	Revised to suit Client's comments	11/05/15	AP	

oea

oconnell east architects
63 Newton Street, Manchester, M1 1ET

t: 0161 839 9380 f: 0161 833 1368

dwg title:	Study Bed Type 1		
job title:	Legge Street for Pochin		
scale:	As indicated @ A3	drawn:	AP
date:	17/04/15	job no:	1511
dwg no:	1511_72_001	rev:	N

© OConnell East Architects - 2016

notes:

All dimensions are in millimetres unless stated otherwise. No dimensions to be scaled from drawings. All dimensions to be checked on site prior to manufacture.

Any discrepancies between drawings and site conditions are to be reported to the contract manager.

This drawing is to be read in conjunction with all relevant Structural Engineers and Mechanical & Electrical Engineers drawings and specification.

Copyright of this drawing and all the information it contains is the sole property of OEA and may not be reproduced or used for any purpose without the written approval of the authors

SB_2a - Schedule

No.	Description	Count
1	Cabin Bed	1
2	Long Side Wall Protector	1
4	Scalloped Desk with Drawer Unit Underneath	1
5	Operators Chair with Arms	1
7	Floor Mounted Bookcase	1
8	Pinboard (Above Bed)	1
9	Framed Mirror	1
11	4 Coat Hooks Mounted on Wall Plate	1
12a	Fire Retardant Curtains (Single) on RAL 9010 PVC Track	1
13	Heater to M&E Specification	1
14	Double Wardrobe - Refer to Matrix	1
16	Pinboard (Above Desk)	1
60	Bed-head Shelf Storage Unit	1

Walls to be framed out for electrics to remove penetrations from air seal line

ELECTRICAL SYMBOL KEY

ss	- Single Socket	tv	- TV Aerial
ds	- Double Socket	fs	- Fused Spur
dsu	- Double Socket with USB charging socket	ha	- Hob Angel Timer
sd	- Single Data (RJ45)	hb	- Heater Booster
dd	- Double Data (RJ45)	eb	- Extract Boost
sl	- Single Light Switch (1 gang)	L	- Bulkhead LED Light to M&E Spec.
dl	- Double Light Switch (2 gang)	R	- Recessed LED Light to M&E Spec.
cc	- Cooker / Hob isolation switch	P	- PIR Sensor
is	- Cooker / Hob isolation switch	FA	- Fire Alarm Sounder & Detector to M&E Spec.
		AH	- Access Hatch

- Electrical sockets and lighting shown for coordination purposes only.
- Lighting to M&E Sub-contractors design to meet RDS lux levels.
- Please refer to M&E sub-contractors drawings for final positions.
- All drawings to be confirmed by Sub-contractors before manufacture
- All Radiator positions to be confirmed by M&E Sub-contractor

dwg status:

CONSTRUCTION

Rev	Description	Date	By	Chk
N	Curtain type revised. Pod setting out note added.	15/09/16	AP	
M	Single Socket Added to Elevation A	23/08/16	IW	AP
L	Furniture revised to Wessex drawings. Construction Issue.	15/08/16	IW	AP
K	Ceiling grid and lighting loop altered to suit client comments.	02/08/16	IW	AP
J	Bedhead sockets added, FS moved to Low level RHS to match M&E.	04/07/16	IW	AP
H	Lighting loop added.	01/04/16	IW	AP
G	Electrics added as per M&E S.C. dwgs.	15/01/16	GM	
F	Full revisions to layout due to change in pod from S4 to S6	10/11/15	AP	
E	General revision.	28/09/15	AP	
D	TENDER ISSUE	22/05/15	AP	
C	Electrical socket key added	18/05/15	AP	
B	Revised to suit Client's comments	14/05/15	AP	
A	Revised to suit Client's comments	11/05/15	AP	

oconnell east architects
63 Newton Street, Manchester, M1 1ET

t: 0161 839 9380 f: 0161 833 1368

dwg title: Study Bed Type 2




job title:
Legge Street
for
Pochin

scale: 1 : 50 @ A3 drawn: AP


date: 26/10/15 job no: 1511

dwg no: 1511_72_002 rev: N

Please note that pod setting out can vary slightly. Refer to GA plans for pod setting out reference (shape). To be used in conjunction with 1511_22_016

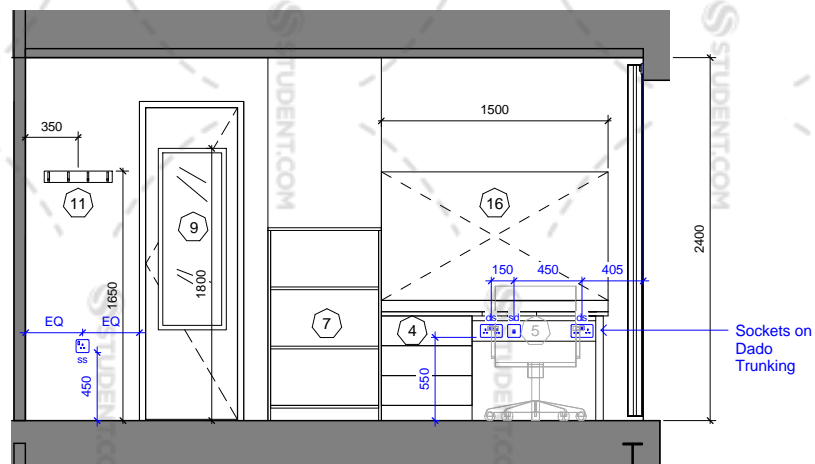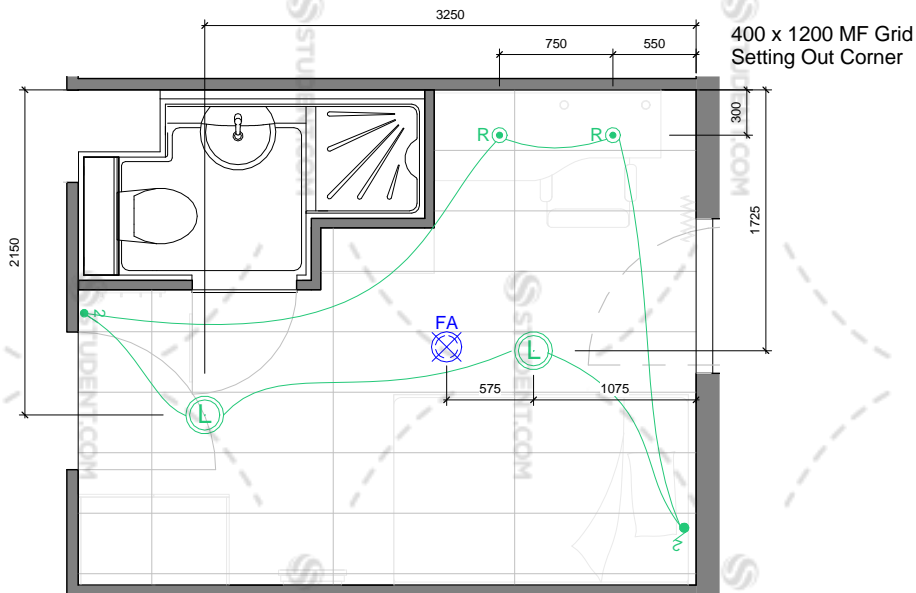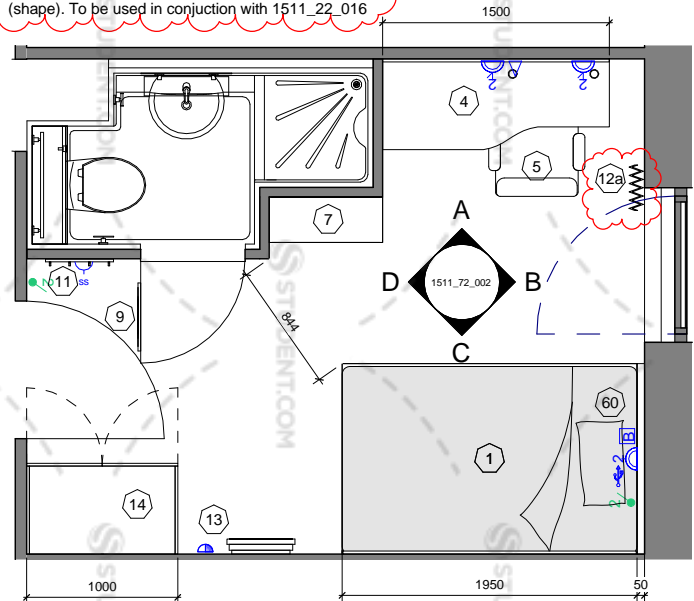


SB_2 - Elevation A
1 : 50

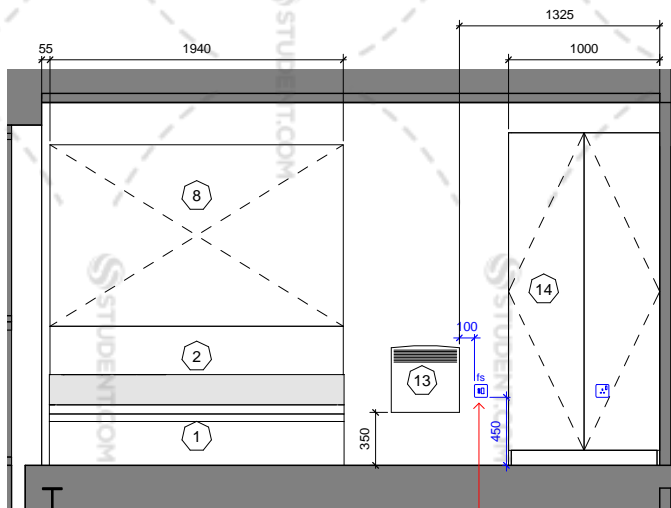


SB_2 - Elevation C
1 : 50

Socket to be installed to right hand side at all times to avoid back to back sockets.

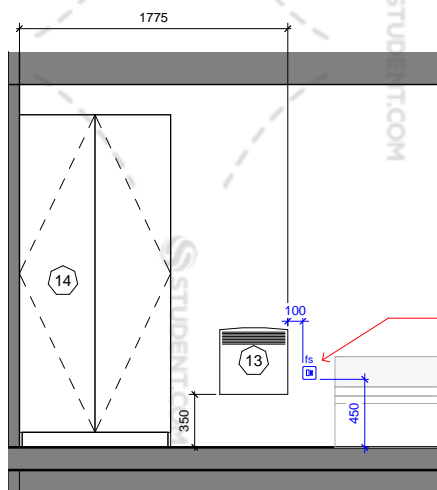


SB_2 - Elevation C (Mirror)
1 : 50


Socket to be installed to right hand side at all times to avoid back to back sockets.

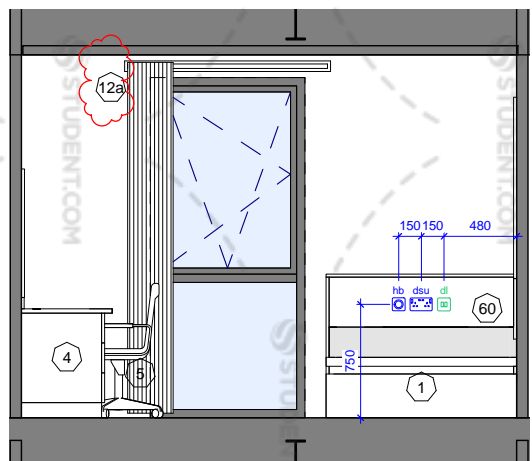

SB_2 - Elevation B
1 : 50


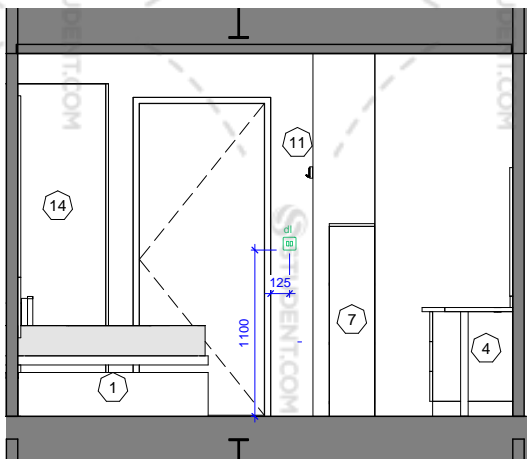


SB_2 - Elevation D
1 : 50

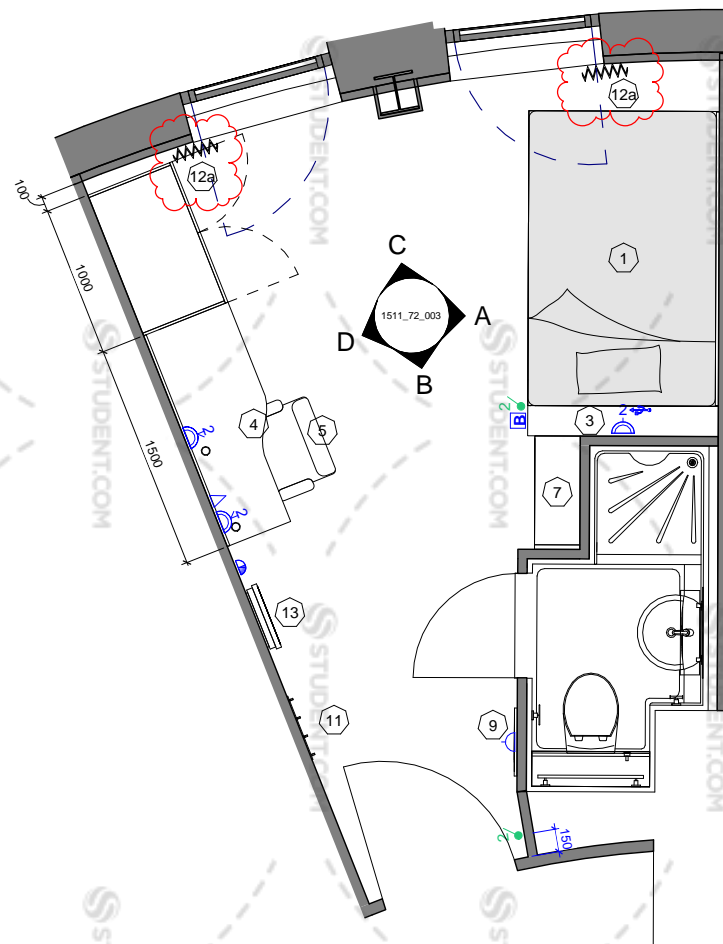


SB_3 - Plan View

 1 : 50

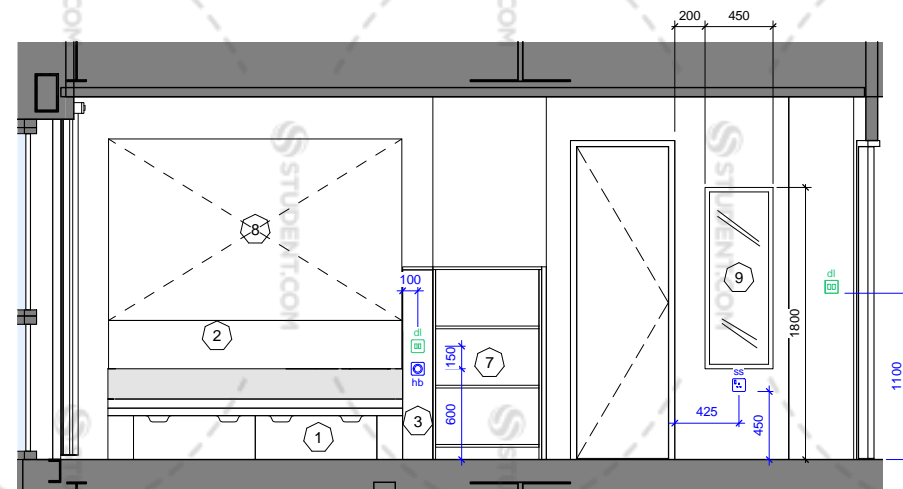


SB_3 - Elevation A

1 : 50

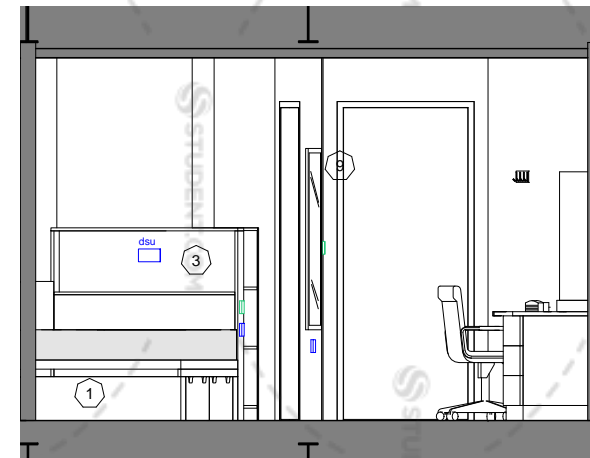


SB_3 - Elevation B

1 : 50

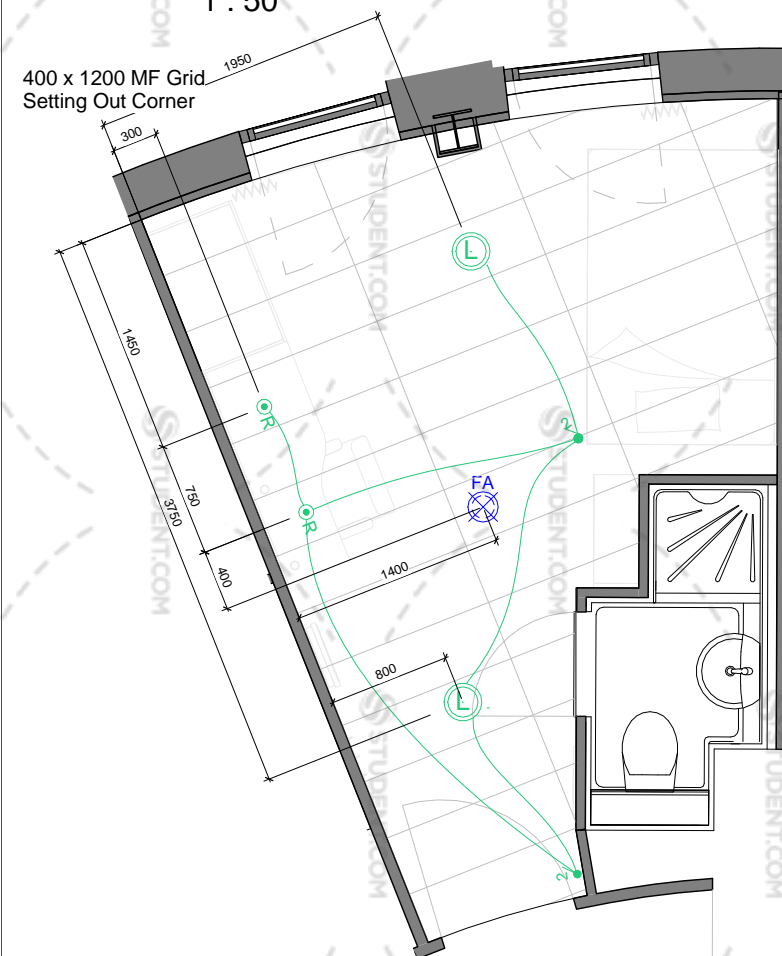


SB_3 - Reflected Ceiling Plan

1 : 50

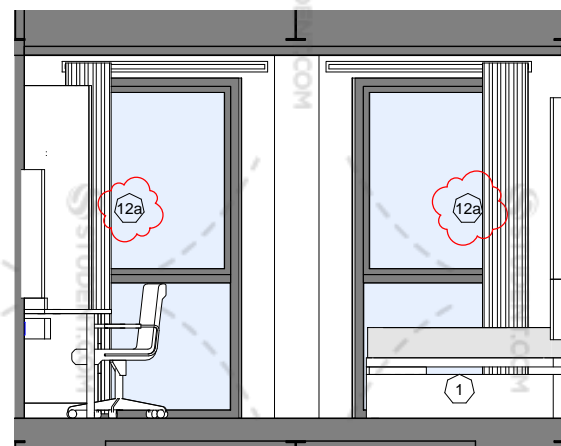

SB_3 - Elevation C

1 : 50

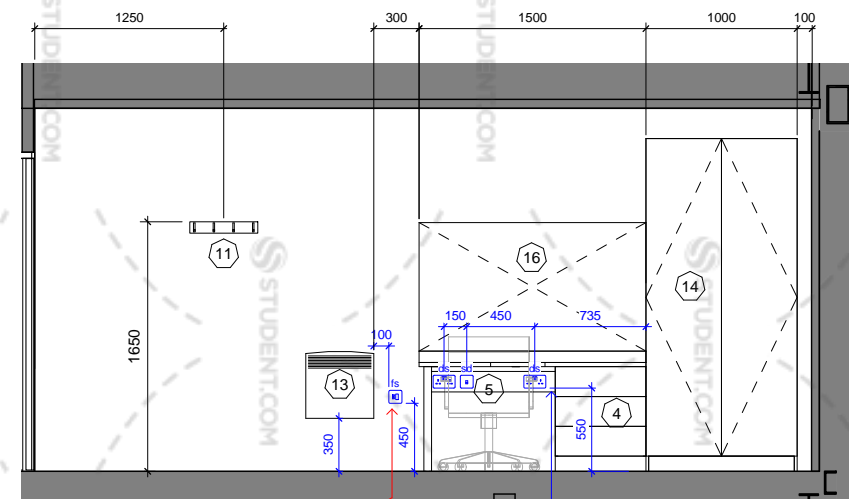

SB_3 - Elevation D

1:50

notes:

All dimensions are in millimetres unless stated otherwise. No dimensions to be scaled from drawings. All dimensions to be checked on site prior to manufacture.


Any discrepancies between drawings and site conditions are to be reported to the contract manager.

This drawing is to be read in conjunction with all relevant Structural Engineers and Mechanical & Electrical Engineers drawings and specification.

Copyright of this drawing and all the information it contains is the sole property of OEA and may not be reproduced or used for any purpose without the written approval of the authors

SB_3 - Schedule

No.	Description	Count
1	Cabin Bed	1
2	Long Side Wall Protector	1
3	Bed-head Shelf Storage Unit	1
4	Scalloped Desk with Drawer Unit Underneath	1
5	Operators Chair with Arms	1
7	Floor Mounted Bookcase	1
8	Pinboard (Above Bed)	1
9	Framed Mirror	1
11	4 Coat Hooks Mounted on Wall Plate	1
12a	Fire Retardant Curtains (Single) on RAL 9010 PVC Track	2
13	Heater to M&E Specification	1
14	Double Wardrobe - Refer to Matrix	1

 Walls to be framed out for electrics to remove penetrations from air seal line

ELECTRICAL SYMBOL KEY

ss	- Single Socket	tv	- TV Aerial
ds	- Double Socket	fs	- Fused Spur
dsu	- Double Socket with USB charging socket	ha	- Hob Angel Timer
sd	- Single Data (RJ45)	hb	- Heater Booster
dd	- Double Data (RJ45)	eb	- Extract Boost
sl	- Single Light Switch (1 gang)	L	- Bulkhead LED Light to M&E Spec.
dl	- Double Light Switch (2 gang)	R	- Recessed LED Light to M&E Spec.
cc	- Cooker wire connection	P	- PIR Sensor
is	- Cooker / Hob isolation switch	FA	- Fire Alarm Sounder & Detector to M&E Spec.
		AH	- Access Hatch

- Electrical sockets and lighting shown for coordination purposes only.
- Lighting to M&E Sub-contractors design to meet RDS lux levels.
- Please refer to M&E sub-contractors drawings for final positions.
- All drawings to be confirmed by Sub-contractor's before manufacture
- All Radiator positions to be confirmed by M&E Sub-contractor

dwg status:


CONSTRUCTION

L	Curtain type revised. Pod setting out note added.	15/09/16	AP	
K	Furniture revised to Wessex drawings.	15/08/16	IW	AP
J	Construction Issue. Ceiling grid and lighting loop altered to suit client comments.	02/08/16	IW	AP
H	Bedhead sockets added, FS moved to Low level RHS to match M&E. Desk flipped. Dimensions added.	04/07/16	IW	AP
G	Heater, wardrobe & desk positions altered. Light loop added.	01/04/16	IW	AP
F	Dimensions added.	15/01/16	GM	
E	General revision.	28/09/15	AP	
D	TENDER ISSUE	22/05/15	AP	
C	Electrical socket key added	18/05/15	AP	
B	Revised to suit Client's comments	14/05/15	AP	
A	Revised to suit Client's comments	11/05/15	AP	
Rev	Description	Date	By	Chk

oconnell east architects
63 Newton Street, Manchester, M1 1ET


t: 0161 839 9380 f: 0161 833 1368

dwg title:	Study Bed Type 3		
job title:	Legge Street for Pochin		
scale:	1 : 50	@ A3	drawn: AP
date:	17/04/15	job no:	1511
dwg no:	1511_72_003		rev: L

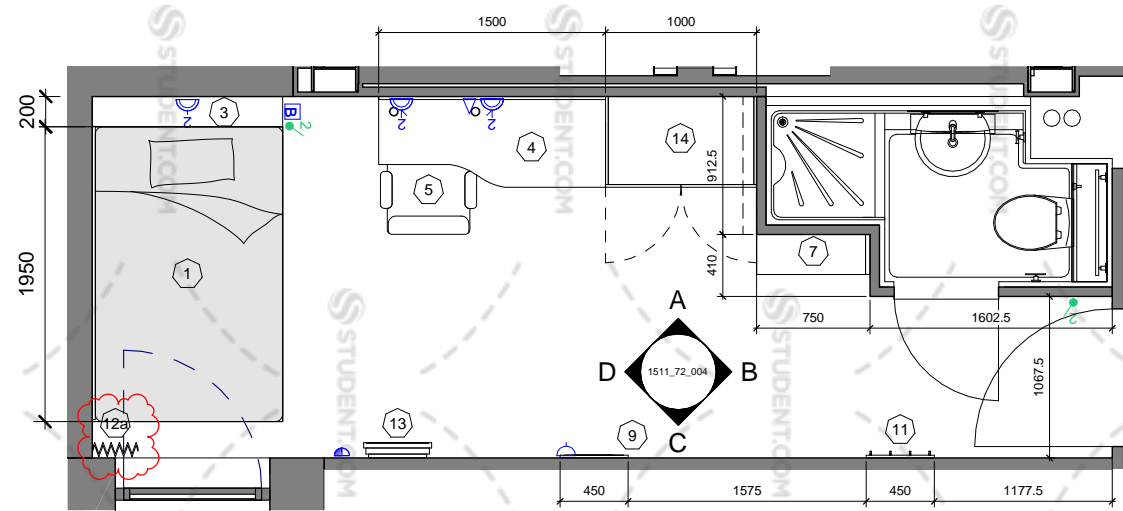

SB_4 - Plan View

1 : 50

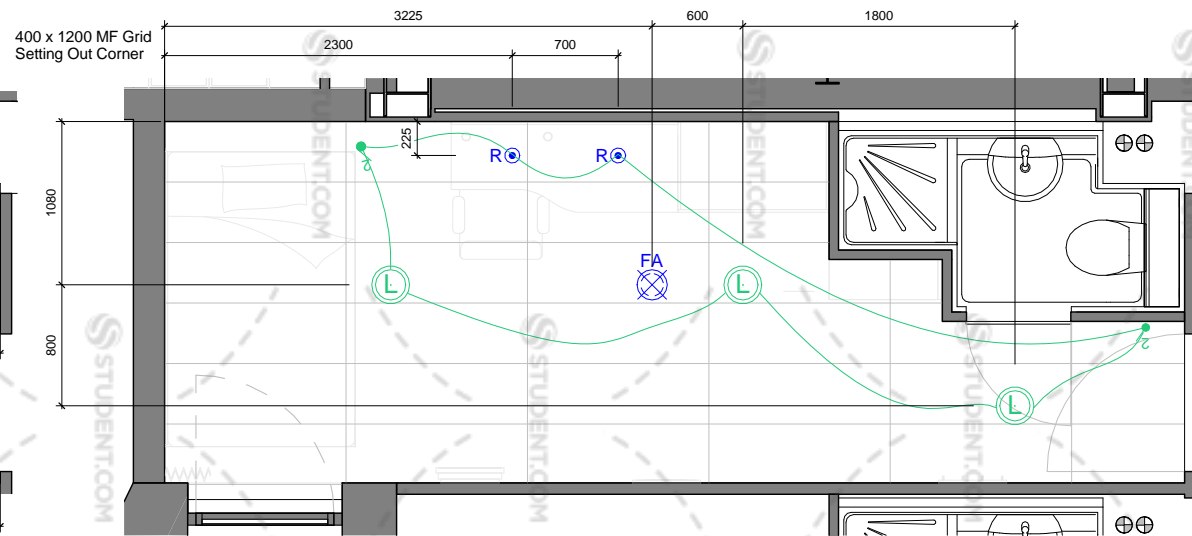

SB_4 - Reflected Ceiling Plan

1 : 50

notes:

All dimensions are in millimetres unless stated otherwise. No dimensions to be scaled from drawings. All dimensions to be checked on site prior to manufacture.

Any discrepancies between drawings and site conditions are to be reported to the contract manager.

This drawing is to be read in conjunction with all relevant Structural Engineers and Mechanical & Electrical Engineers drawings and specification.

Copyright of this drawing and all the information it contains is the sole property of OEA and may not be reproduced or used for any purpose without the written approval of the authors

SB_4 - Schedule

No.	Description	Count
1	Cabin Bed	1
2	Long Side Wall Protector	1
3	Bed-head Shelf Storage Unit	1
4	Scalloped Desk with Drawer Unit Undereath	1
5	Operators Chair with Arms	1
7	Floor Mounted Bookcase	1
8	Pinboard (Above Bed)	1
9	Framed Mirror	1
11	4 Coat Hooks Mounted on Wall Plate	1
12a	Fire Retardant Curtains (Single) on RAL 9010 PVC Track	1
13	Heater to M&E Specification	1
14	Double Wardrobe - Refer to Matrix	1
16	Pinboard (Above Desk)	1

Walls to be framed out for electrics to remove penetrations from air seal line

ELECTRICAL SYMBOL KEY

ss	- Single Socket	tv	- TV Aerial
ds	- Double Socket	fs	- Fused Spur
dsu	- Double Socket with USB charging socket	ha	- Hob Angel Timer
sd	- Single Data (RJ45)	hb	- Heater Booster
dd	- Double Data (RJ45)	eb	- Extract Boost
sl	- Single Light Switch (1 gang)	L	- Bulkhead LED Light to M&E Spec.
dl	- Double Light Switch (2 gang)	R	- Recessed LED Light to M&E Spec.
cc	- Cooker wire connection	P	- PIR Sensor
is	- Cooker / Hob isolation switch	FA	- Fire Alarm Sounder & Detector to M&E Spec.
		AH	- Access Hatch

- Electrical sockets and lighting shown for coordination purposes only.
- Lighting to M&E Sub-contractors design to meet RDS lux levels.
- Please refer to M&E sub-contractors drawings for final positions.
- All drawings to be confirmed by Sub-contractor's before manufacture
- All Radiator positions to be confirmed by M&E Sub-contractor

dwg status:


CONSTRUCTION

Rev	Description	Date	By	Chk
L	Curtain type revised. Pod setting out added.	15/09/16	AP	
K	Furniture revised to Wessex drawings. Construction Issue.	15/08/16	IW	AP
J	Ceiling grid and lighting loop altered to suit client comments.	02/08/16	IW	AP
H	Bedhead sockets added, FS moved to Low level RHS to match M&E	04/07/16	IW	AP
G	Layout revised to client comments. Lighting loop added.	01/04/16	IW	AP
F	RCP revised to match M&E S.C. dwgs. Dimensions added.	15/01/16	GM	
E	General revision.	28/09/15	AP	
D	TENDER ISSUE	22/05/15	AP	
C	Electrical socket key added	18/05/15	AP	
B	Revised to suit Client's comments	14/05/15	AP	
A	Revised to suit Client's comments	11/05/15	AP	

oconnell east architects
63 Newton Street, Manchester, M1 1ET


t: 0161 839 9380 f: 0161 833 1368

dwg title:	Study Bed Type 4
job title:	Legge Street for Pochin
scale:	1 : 50 @ A3
date:	17/04/15
dwg no:	1511_72_004
drawn:	AP
job no:	1511
rev:	L

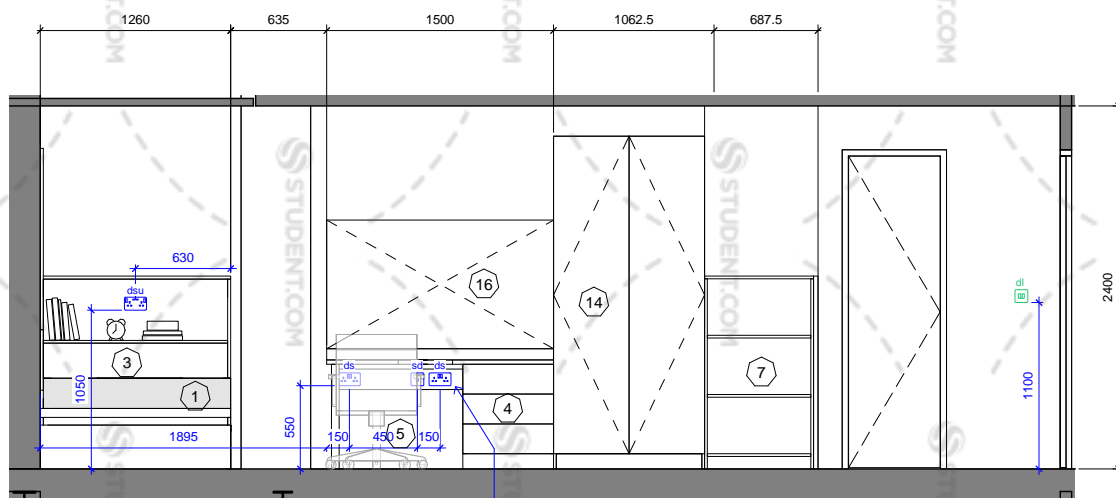


SB_4 - Elevation A

1 : 50

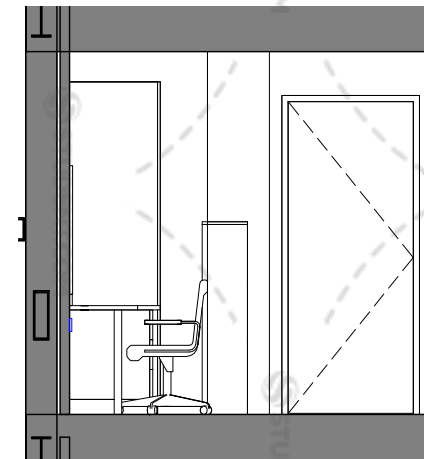


SB_4 - Elevation B

1 : 50

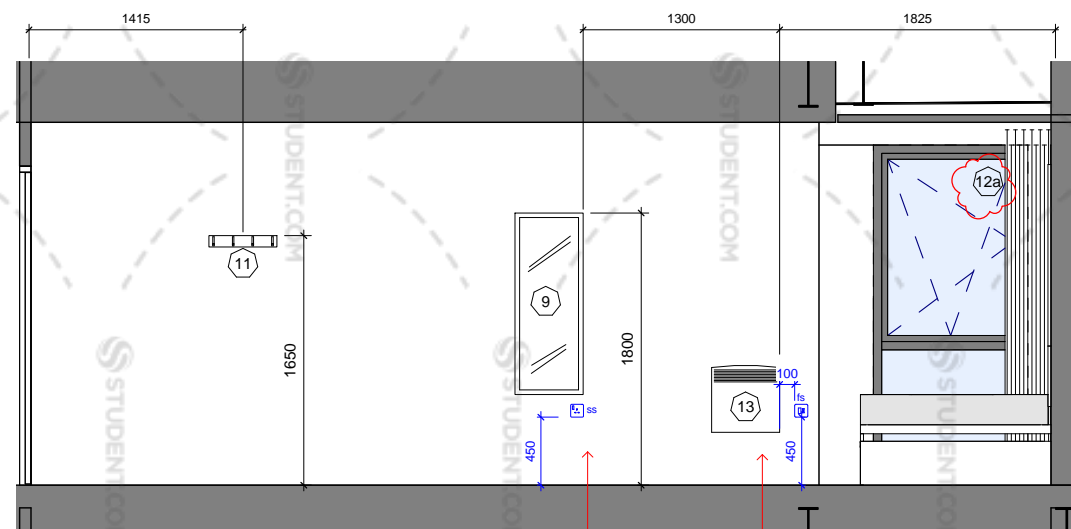


SB_4 - Elevation C

1 : 50

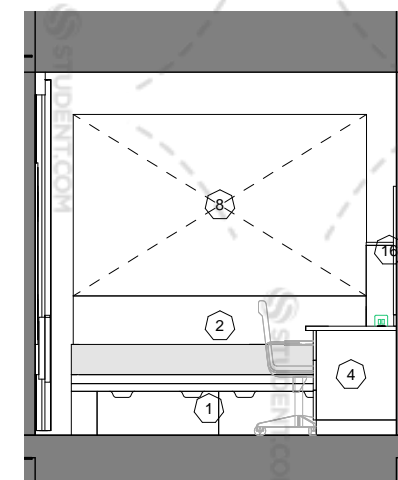


SB_4 - Elevation D

1 : 50

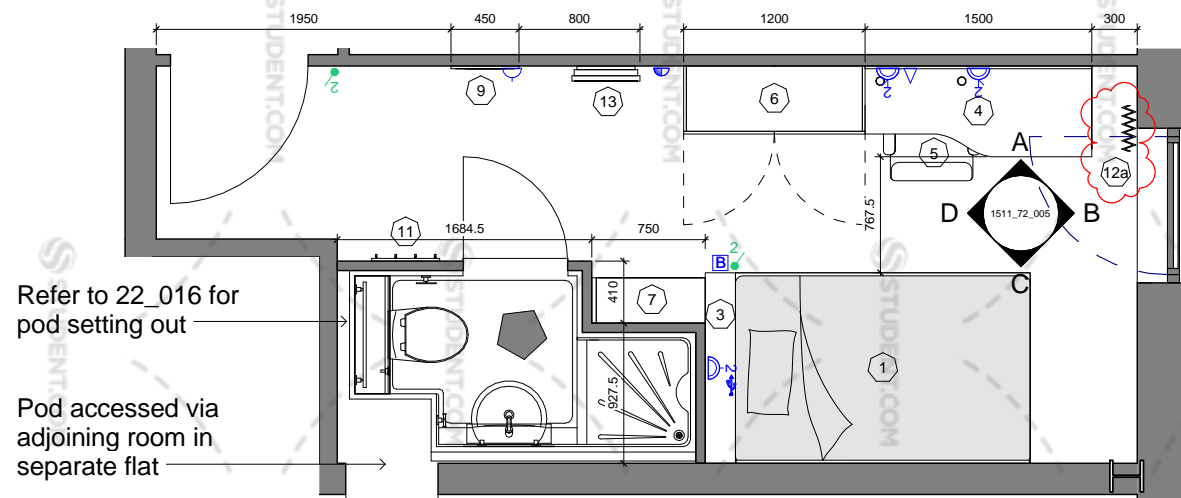


SB_5 - Plan View

1 : 50

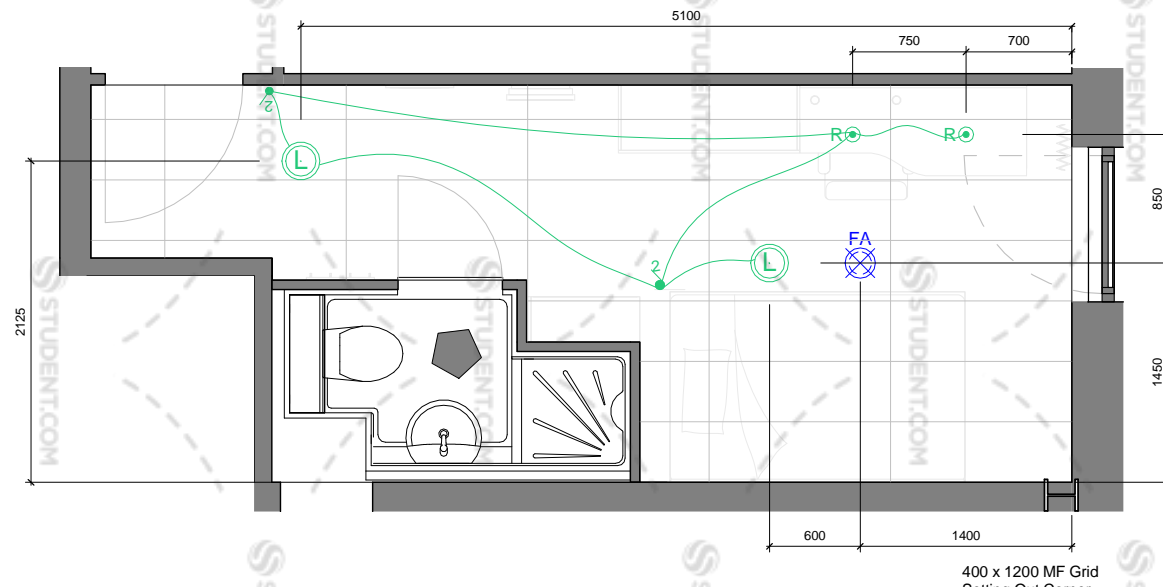

SB_5 - Reflected Ceiling Plan

1 : 50

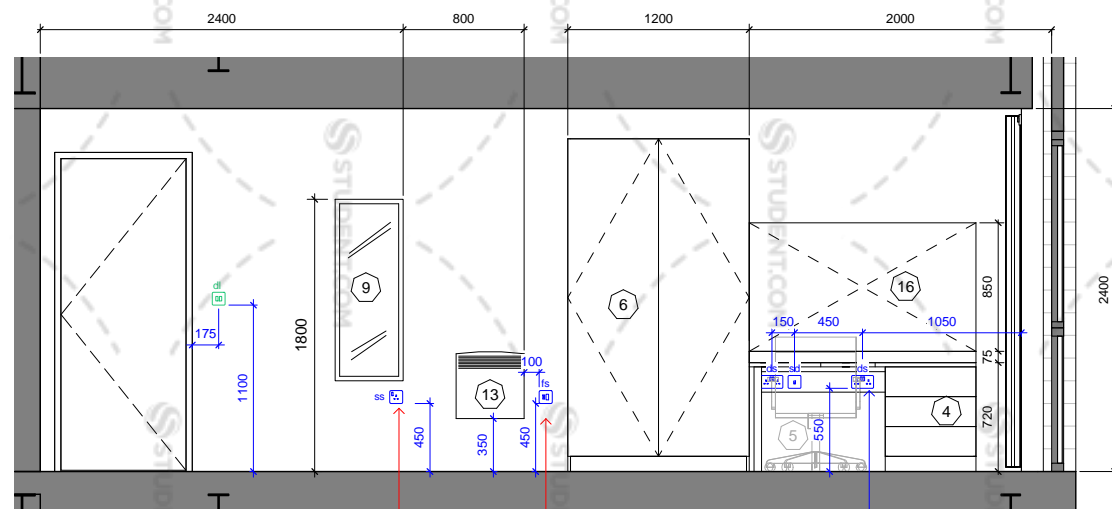


SB_5 - Elevation A

1 : 50


Socket to be installed to right hand side at all times to avoid back to back sockets.

Sockets on Dado Trunking

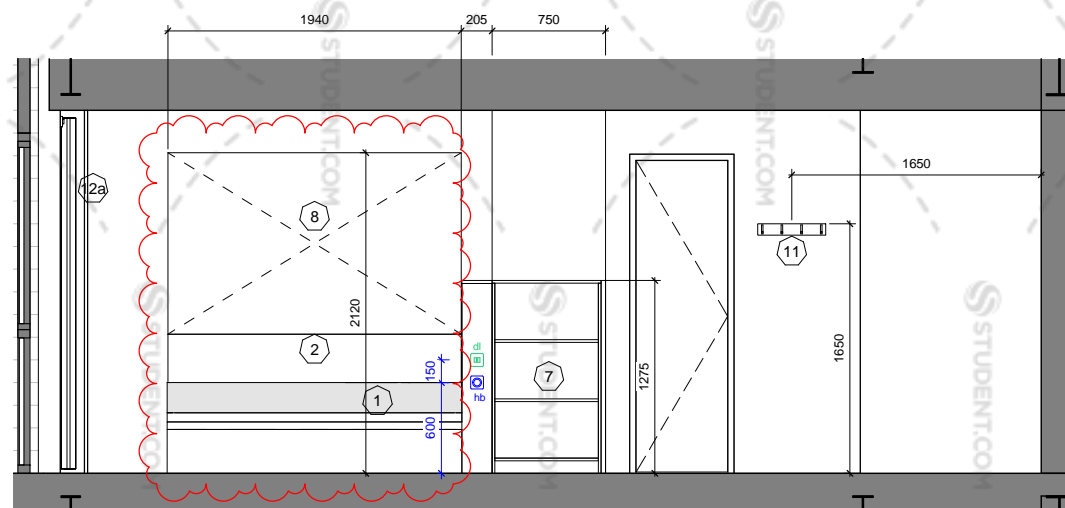


SB_5 - Elevation C

1 : 50

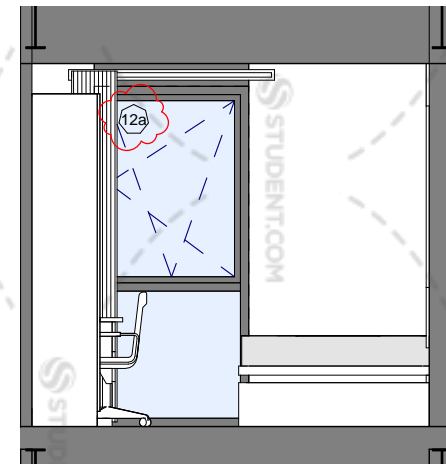

SB_5 - Elevation B

1 : 50

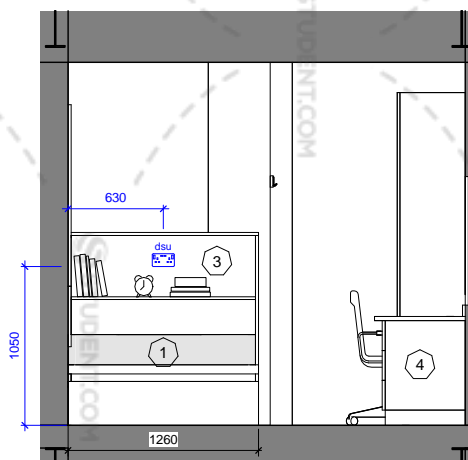

SB_5 - Elevation D

1 : 50

notes:

All dimensions are in millimetres unless stated otherwise. No dimensions to be scaled from drawings. All dimensions to be checked on site prior to manufacture.

Any discrepancies between drawings and site conditions are to be reported to the contract manager.

This drawing is to be read in conjunction with all relevant Structural Engineers and Mechanical & Electrical Engineers drawings and specification.

Copyright of this drawing and all the information it contains is the sole property of OEA and may not be reproduced or used for any purpose without the written approval of the authors

SB_5 - Schedule

No.	Description	Count
1	Cabin Bed	1
2	Long Side Wall Protector	1
3	Bed-head Shelf Storage Unit	1
4	Scalloped Desk with Drawer Unit Undemeath	1
5	Operators Chair with Arms	1
6	Double Wardrobe - Refer to Matrix	1
7	Floor Mounted Bookcase	1
8	Pinboard (Above Bed)	1
9	Framed Mirror	1
11	4 Coat Hooks Mounted on Wall Plate	1
12a	Fire Retardant Curtains (Single) on RAL 9010 PVC Track	1
13	Heater to M&E Specification	1

Walls to be framed out for electrics to remove penetrations from air seal line

ELECTRICAL SYMBOL KEY

ss - Single Socket	tv - TV Aerial
ds - Double Socket	fs - Fused Spur
dsu - Double Socket with USB charging socket	ha - Hob Angel Timer
sd - Single Data (RJ45)	hb - Heater Booster
dd - Double Data (RJ45)	eb - Extract Boost
sl - Single Light Switch (1 gang)	L - Bulkhead LED Light to M&E Spec.
dl - Double Light Switch (2 gang)	R - Recessed LED Light to M&E Spec.
cc - Cooker wire connection	P - PIR Sensor
is - Cooker / Hob isolation switch	FA - Fire Alarm Sounder & Detector to M&E Spec.
	AH - Access Hatch

- Electrical sockets and lighting shown for coordination purposes only.
- Lighting to M&E Sub-contractors design to meet RDS lux levels.
- Please refer to M&E sub-contractors drawings for final positions.
- All drawings to be confirmed by Sub-contractor's before manufacture
- All Radiator positions to be confirmed by M&E Sub-contractor

dwg status:

CONSTRUCTION

Rev	Description	Date	By	Chk
L	Curtain type revised. Pod setting out note added.	15/09/16	AP	
K	Furniture revised to Wessex drawings. Construction Issue.	15/08/16	IW	AP
J	Ceiling grid and lighting loop altered to suit client comments.	02/08/16	IW	AP
H	Bedhead sockets added, FS moved to Low level RHS to match M&E	04/07/16	IW	AP
G	Relocated coat hooks. Wardrobe size revised. Lighting loop added.	01/04/16	IW	AP
F	Dimensions added. Pod access note revised.	15/01/16	GM	
E	General revision.	28/09/15	AP	
D	TENDER ISSUE	22/05/15	AP	
C	Electrical socket key added	18/05/15	AP	
B	Revised to suit Client's comments	14/05/15	AP	
A	Revised to suit Client's comments	11/05/15	AP	

oea

oconnell east architects
63 Newton Street, Manchester, M1 1ET

t: 0161 839 9380 f: 0161 833 1368

dwg title:	Study Bed Type 5		
job title:	Legge Street for Pochin		
scale:	1 : 50 @ A3	drawn:	AP
date:	17/04/15	job no:	1511
dwg no:	1511_72_005	rev:	L

© OConnell East Architects - 2016

notes:

All dimensions are in millimetres unless stated otherwise. No dimensions to be scaled from drawings. All dimensions to be checked on site prior to manufacture.

Any discrepancies between drawings and site conditions are to be reported to the contract manager.

This drawing is to be read in conjunction with all relevant Structural Engineers and Mechanical & Electrical Engineers drawings and specification.

Copyright of this drawing and all the information it contains is the sole property of OEA and may not be reproduced or used for any purpose without the written approval of the authors

SB_6 - Schedule

No.	Description	Count
1	Cabin Bed	1
2	Long Side Wall Protector	1
3	Bed-head Shelf Storage Unit	1
4	Scalloped Desk with Drawer Unit Undereath	1
5	Operators Chair with Arms	1
7	Floor Mounted Bookcase	1
8	Pinboard (Above Bed)	1
9	Framed Mirror	1
11	4 Coat Hooks Mounted on Wall Plate	1
12a	Fire Retardant Curtains (Single) on RAL 9010 PVC Track	1
13	Heater to M&E Specification	1
14	Double Wardrobe - Refer to Matrix	1
16	Pinboard (Above Desk)	1

Walls to be framed out for electrics to remove penetrations from air seal line

ELECTRICAL SYMBOL KEY

ss - Single Socket	tv - TV Aerial
ds - Double Socket	fs - Fused Spur
dsu - Double Socket with USB charging socket	ha - Hob Angel Timer
sd - Single Data (RJ45)	hb - Heater Booster
dd - Double Data (RJ45)	eb - Extract Boost
sl - Single Light Switch (1 gang)	L - Bulkhead LED Light to M&E Spec.
dl - Double Light Switch (2 gang)	R - Recessed LED Light to M&E Spec.
cc - Cooker wire connection	P - PIR Sensor
is - Cooker / Hob isolation switch	FA - Fire Alarm Sounder & Detector to M&E Spec.
	AH - Access Hatch

- Electrical sockets and lighting shown for coordination purposes only.
- Lighting to M&E Sub-contractors design to meet RDS lux levels.
- Please refer to M&E sub-contractors drawings for final positions.
- All drawings to be confirmed by Sub-contractor's before manufacture
- All Radiator positions to be confirmed by M&E Sub-contractor

dwg status:

CONSTRUCTION

Rev	Description	Date	By	Chk
M	Curtain type revised. Pod setting out note added.	15/09/16	AP	
L	Socket added to Elevation C	23/08/16	IW	AP
K	Furniture revised to Wessex drawings. Construction Issue.	15/08/16	IW	AP
J	Ceiling grid and lighting loop altered to suit client comments.	02/08/16	IW	AP
H	Bedhead sockets added, FS moved to Low level RHS to match M&E	04/07/16	IW	AP
G	Relocation of light switch and coat hooks. Lighting loop added.	01/04/16	IW	AP
F	Dimensions added. Heater repositioned.	15/01/16	GM	
E	General revision.	28/09/15	AP	
D	TENDER ISSUE	22/05/15	AP	
C	Electrical socket key added	18/05/15	AP	
B	Revised to suit Client's comments	14/05/15	AP	
A	Revised to suit Client's comments	11/05/15	AP	


oea

oconnell east architects
63 Newton Street, Manchester, M1 1ET

t: 0161 839 9380 f: 0161 833 1368


dwg title:	Study Bed Type 6		
job title:	Legge Street for Pochin		
scale:	1 : 50	@ A3	drawn: AP
date:	17/04/15	job no:	1511
dwg no:	1511_72_006	rev:	M

© OConnell East Architects - 2016

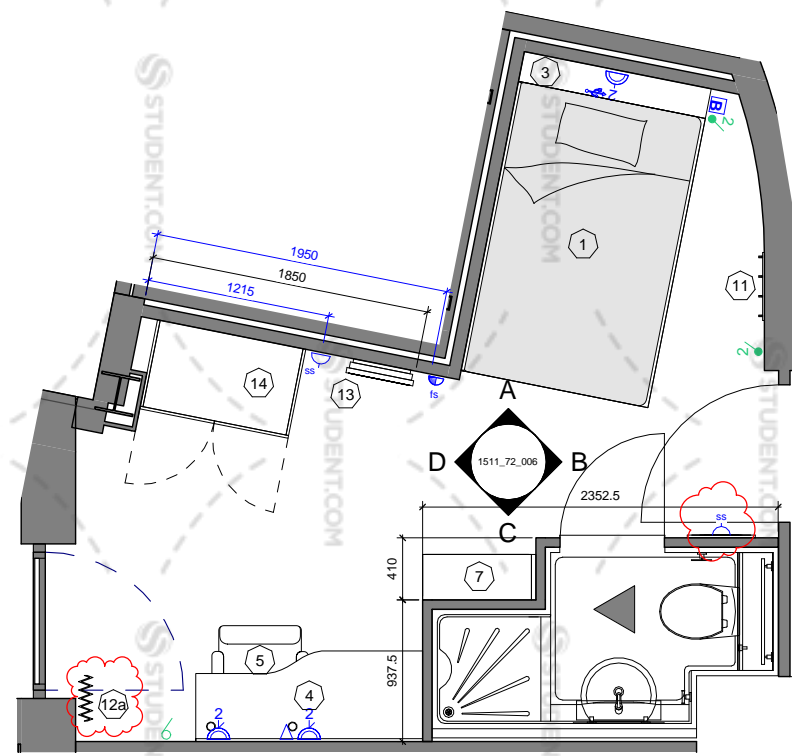


SB_6 - Plan View

1 : 50

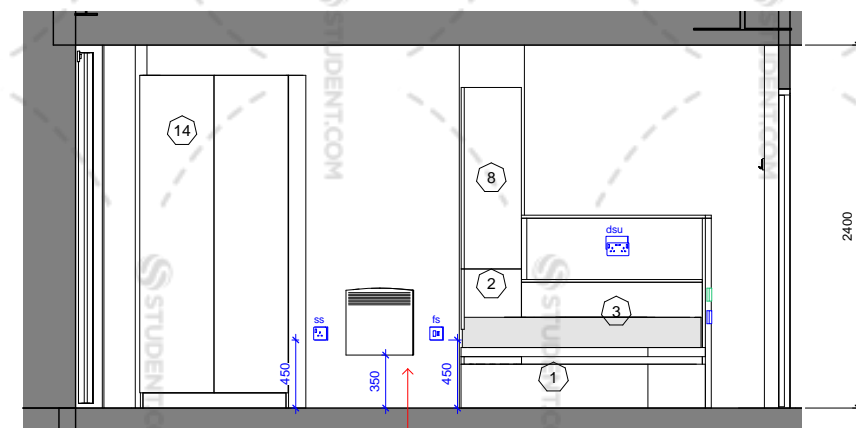


SB_6 - Elevation A

1 : 50

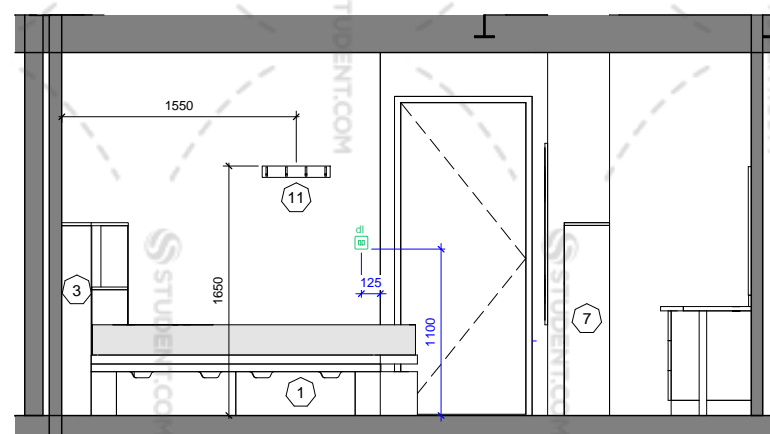


SB_6 - Elevation B

1 : 50

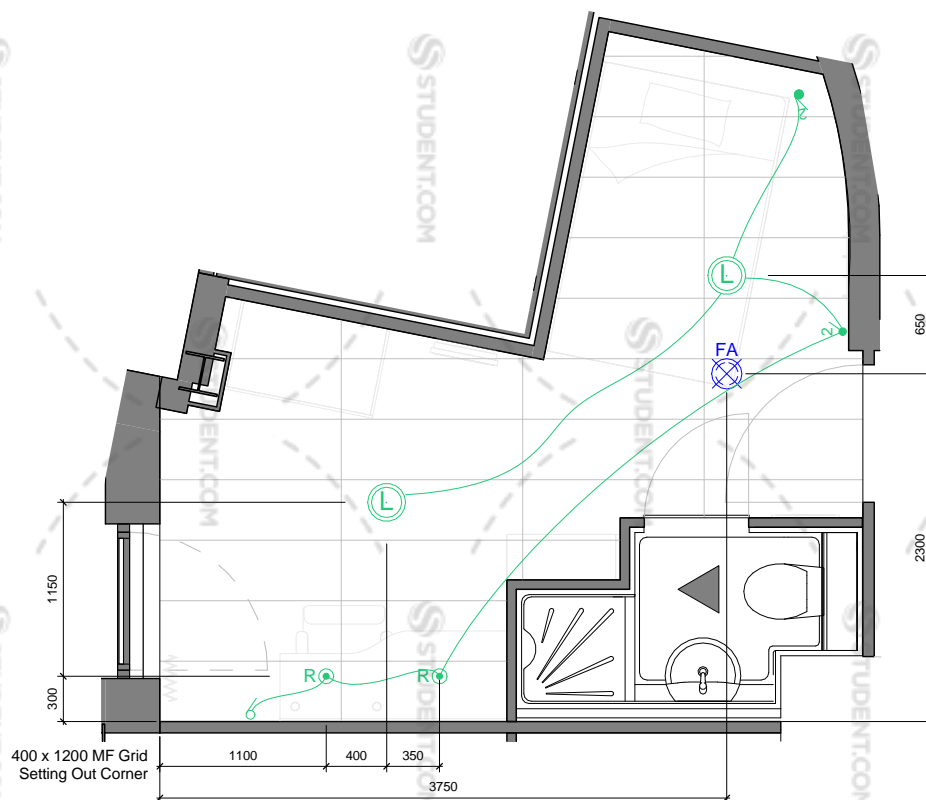


SB_6 - Reflected Ceiling Plan

1 : 50

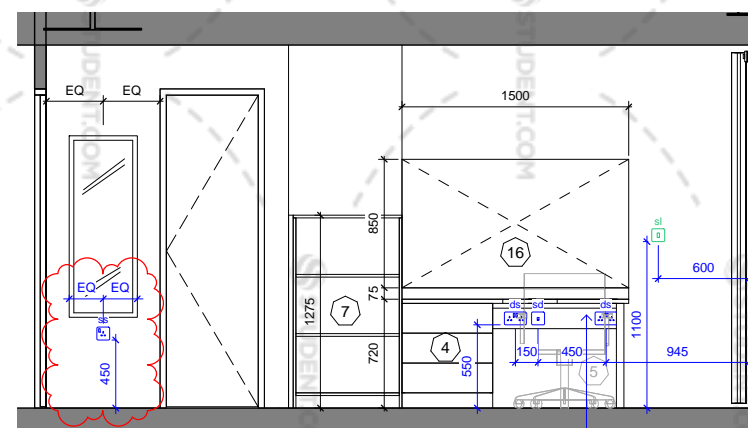


SB_6 - Elevation C

1 : 50

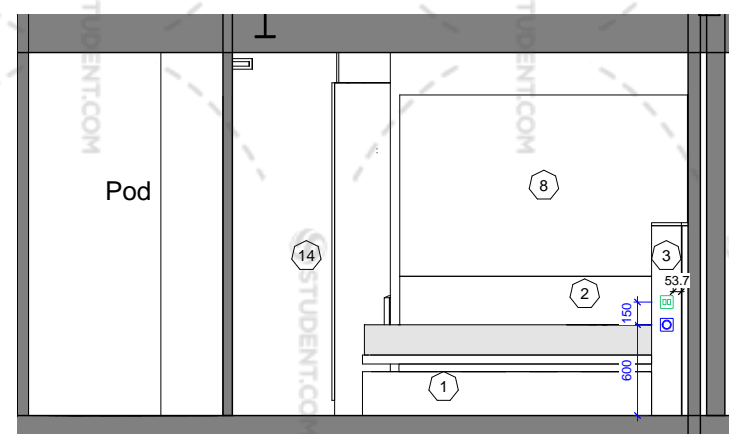

SB_6 - Elevation D


1 : 50

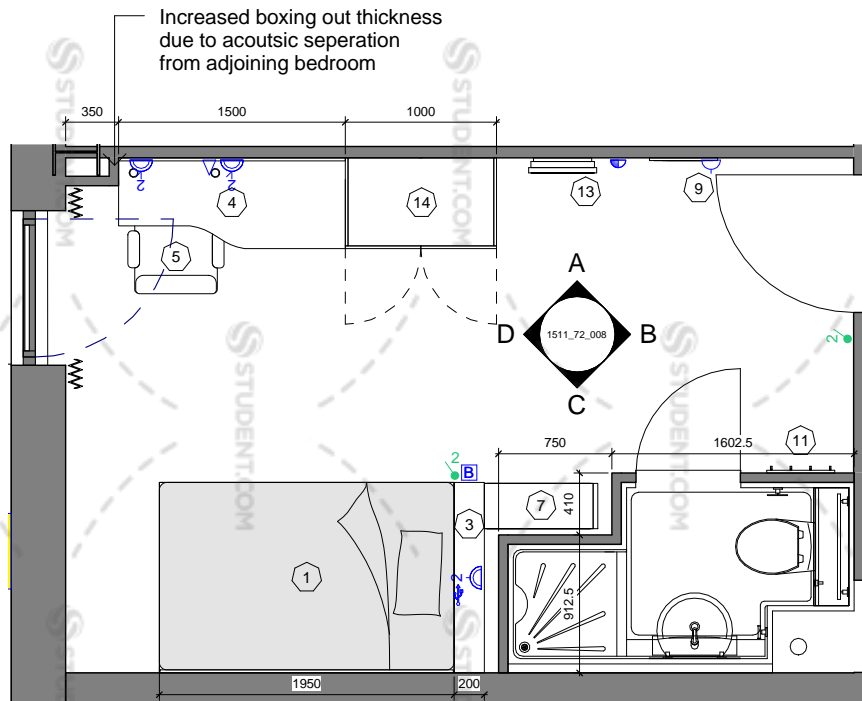

SB_8 - Plan View

1 : 50

Refer to 22_016 for Pod Setting Out

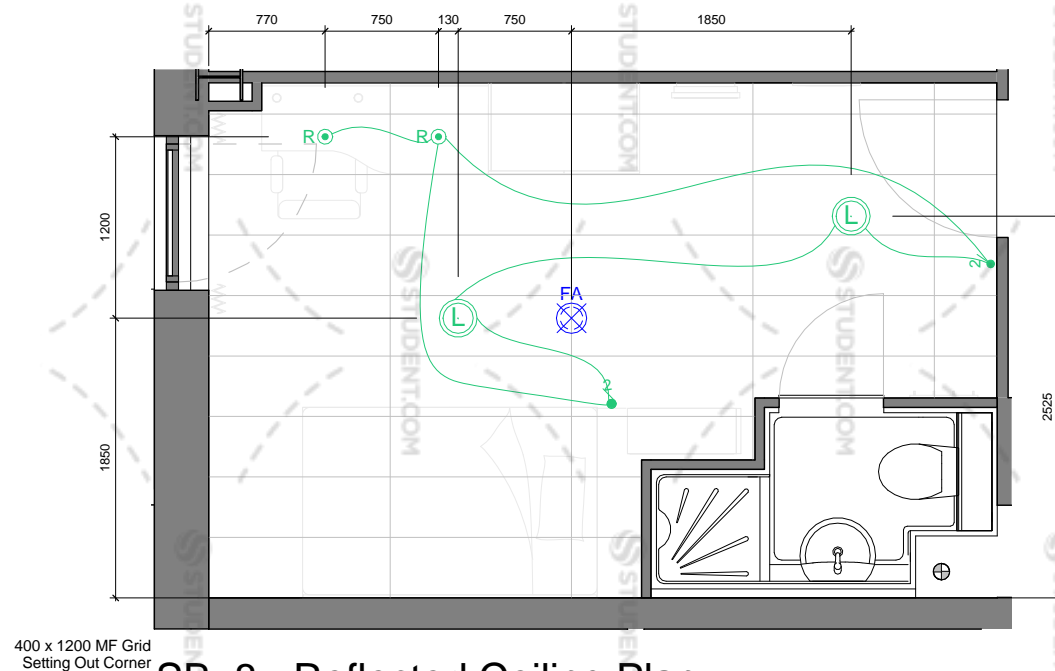

SB_8 - Reflected Ceiling Plan

1 : 50

400 x 1200 MF Grid
Setting Out Corner

notes:

All dimensions are in millimetres unless stated otherwise. No dimensions to be scaled from drawings. All dimensions to be checked on site prior to manufacture.

Any discrepancies between drawings and site conditions are to be reported to the contract manager.

This drawing is to be read in conjunction with all relevant Structural Engineers and Mechanical & Electrical Engineers drawings and specification.

Copyright of this drawing and all the information it contains is the sole property of OEA and may not be reproduced or used for any purpose without the written approval of the authors

SB_8 - Schedule

No.	Description	Count
1	Cabin Bed	1
2	Long Side Wall Protector	1
3	Bed-head Shelf Storage Unit	1
4	Scalloped Desk with Drawer Unit Undneath	1
5	Operators Chair with Arms	1
7	Floor Mounted Bookcase	1
8	Pinboard (Above Bed)	1
9	Framed Mirror	1
11	4 Coat Hooks Mounted on Wall Plate	1
12	Fire Retardant Curtains on RAL 9010 PVC Track - Pair	1
13	Heater to M&E Specification	1
14	Double Wardrobe - Refer to Matrix	1
16	Pinboard (Above Desk)	1

Walls to be framed out for electrics to remove penetrations from air seal line

ELECTRICAL SYMBOL KEY

ss - Single Socket	tv - TV Aerial
ds - Double Socket	fs - Fused Spur
dsu - Double Socket with USB charging socket	ha - Hob Angel Timer
sd - Single Data (RJ45)	hb - Heater Booster
dd - Double Data (RJ45)	eb - Extract Boost
sl - Single Light Switch (1 gang)	L - Bulkhead LED Light to M&E Spec.
dl - Double Light Switch (2 gang)	R - Recessed LED Light to M&E Spec.
cc - Cooker wire connection	P - PIR Sensor
is - Cooker / Hob isolation switch	FA - Fire Alarm Sounder & Detector to M&E Spec.
	AH - Access Hatch

- Electrical sockets and lighting shown for coordination purposes only.
- Lighting to M&E Sub-contractors design to meet RDS lux levels.
- Please refer to M&E sub-contractors drawings for final positions.
- All drawings to be confirmed by Sub-contractor's before manufacture
- All Radiator positions to be confirmed by M&E Sub-contractor

dwg status:


CONSTRUCTION

Rev	Description	Date	By	Chk
L	Curtain type revised. Pod setting out note added.	15/09/16	AP	
K	Furniture revised to Wessex drawings. Construction Issue.	15/08/16	IW	AP
J	Ceiling grid and lighting loop altered to suit client comments.	02/08/16	IW	AP
H	Bedhead sockets added, FS moved to Low level RHS to match M&E	04/07/16	IW	AP
G	Heater repositioned. Lighting loop added.	01/04/16	IW	AP
F	Dimensions added. Heater repositioned.	15/01/16	GM	
E	General revision.	28/09/15	AP	
D	TENDER ISSUE	22/05/15	AP	
C	Electrical socket key added	18/05/15	AP	
B	Revised to suit Client's comments	14/05/15	AP	
A	Revised to suit Client's comments	11/05/15	AP	

oconnell east architects
63 Newton Street, Manchester, M1 1ET

t: 0161 839 9380 f: 0161 833 1368


dwg title:	Study Bed Type 8		
job title:	Legge Street for Pochin		
scale:	1 : 50 @ A3	drawn:	AP
date:	17/04/15	job no:	1511
dwg no:	1511_72_008	rev:	L

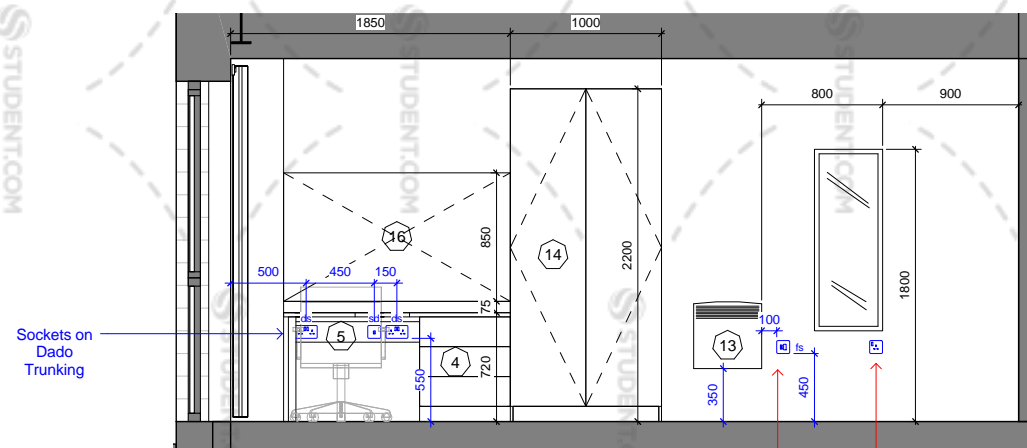

SB_8 - Elevation A


1 : 50

Socket to be installed to right hand side at all times to avoid back to back sockets.

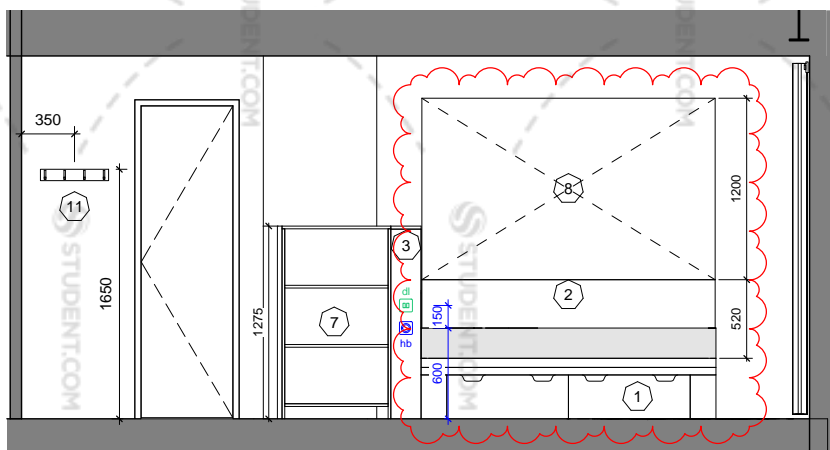


SB_8 - Elevation C

1 : 50

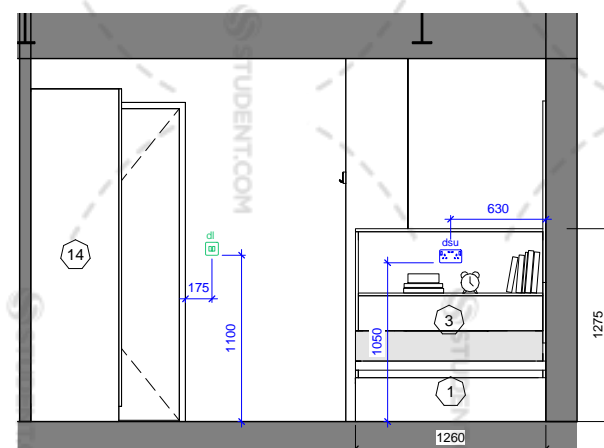

SB_8 - Elevation B

1 : 50

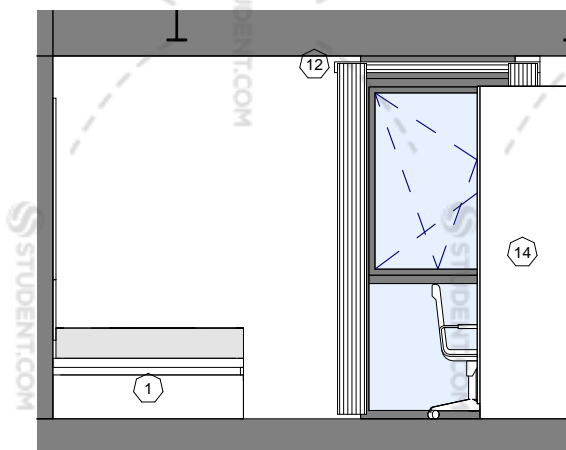

SB_8 - Elevation D

1 : 50

notes:

All dimensions are in millimetres unless stated otherwise. No dimensions to be scaled from drawings. All dimensions to be checked on site prior to manufacture.

Any discrepancies between drawings and site conditions are to be reported to the contract manager.

This drawing is to be read in conjunction with all relevant Structural Engineers and Mechanical & Electrical Engineers drawings and specification.

Copyright of this drawing and all the information it contains is the sole property of OEA and may not be reproduced or used for any purpose without the written approval of the authors

SB_11 - Schedule

No.	Description	Count
1	Cabin Bed	1
2	Long Side Wall Protector	1
3	Bed-head Shelf Storage Unit	1
5	Operators Chair with Arms	1
8	Pinboard (Above Bed)	1
9	Framed Mirror	1
11	4 Coat Hooks Mounted on Wall Plate	1
12a	Fire Retardant Curtains (Single) on RAL 9010 PVC Track	1
13	Heater to M&E Specification	1
14	Double Wardrobe - Refer to Matrix	1
29	Wall Mounted 3 Shelf Storage Unit	1
74	Scalloped Desk with Drawer Unit Undereath	1
75	Pinboard (Above Desk) (1050 x 1200)	1

Walls to be framed out for electrics to remove penetrations from air seal line

ELECTRICAL SYMBOL KEY

ss	- Single Socket	tv	- TV Aerial
ds	- Double Socket	fs	- Fused Spur
dsu	- Double Socket with USB charging socket	ha	- Hob Angel Timer
sd	- Single Data (RJ45)	hb	- Heater Booster
dd	- Double Data (RJ45)	eb	- Extract Boost
sl	- Single Light Switch (1 gang)	L	- Bulkhead LED Light to M&E Spec.
dl	- Double Light Switch (2 gang)	R	- Recessed LED Light to M&E Spec.
cc	- Cooker wire connection	P	- PIR Sensor
is	- Cooker / Hob isolation switch	FA	- Fire Alarm Sounder & Detector to M&E Spec.
		AH	- Access Hatch

- Electrical sockets and lighting shown for coordination purposes only.
- Lighting to M&E Sub-contractors design to meet RDS lux levels.
- Please refer to M&E sub-contractors drawings for final positions.
- All drawings to be confirmed by Sub-contractor's before manufacture
- All Radiator positions to be confirmed by M&E Sub-contractor

dwg status:


CONSTRUCTION

M	Curtain type revised. Pod setting out note added.	15/09/16	AP	
L	Furniture revised to Wessex drawings. Bedhead light switch removed by request. Lighting loop and symbols altered to match. Construction Issue.	15/08/16	IW	AP
K	Ceiling grid and lighting loop altered to suit client comments.	02/08/16	IW	AP
J	Bedhead sockets added, FS added to match M&E. Desk revised based on S.C. comments.	04/07/16	IW	AP
H	Lighting loop added.	01/04/16	IW	AP
G	Wall framing out added.	26/01/16	AP	
F	RCP revised to match M&E S.C. dwgs. Dimensions added.	15/01/16	GM	
E	General revision.	28/09/15	AP	
D	TENDER ISSUE	22/05/15	AP	
C	Electrical socket key added	18/05/15	AP	
B	Revised to suit Client's comments	14/05/15	AP	
A	Revised to suit Client's comments	11/05/15	AP	
Rev	Description	Date	By	Chk

oconnell east architects
63 Newton Street, Manchester, M1 1ET


t: 0161 839 9380 f: 0161 833 1368

dwg title:	Study Bed Type 11		
job title:	Legge Street for Pochin		
scale:	1 : 50	@ A3	drawn: AP
date:	17/04/15	job no:	1511
dwg no:	1511_72_011	rev:	M

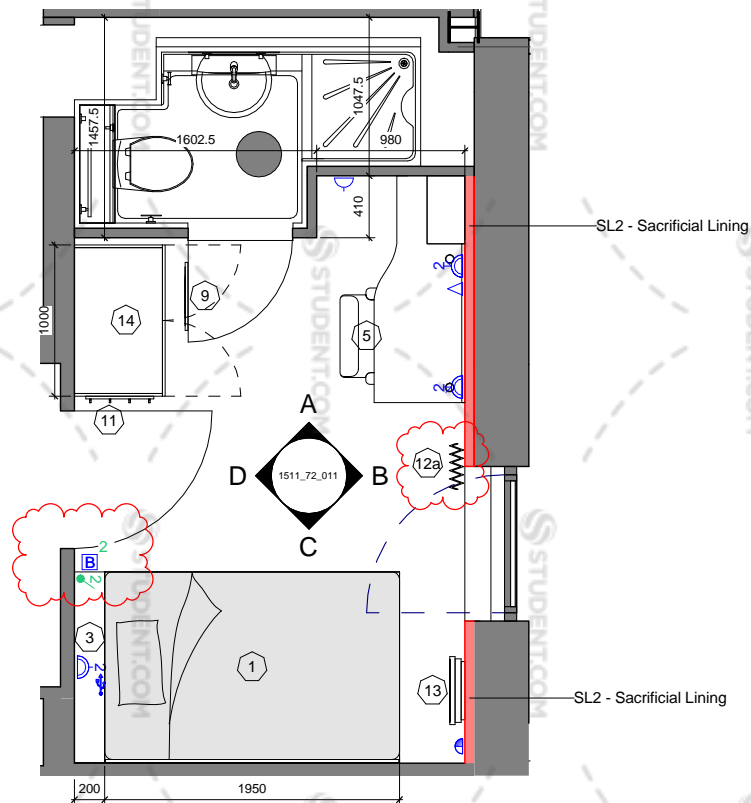


SB_11 - Plan View

1 : 50

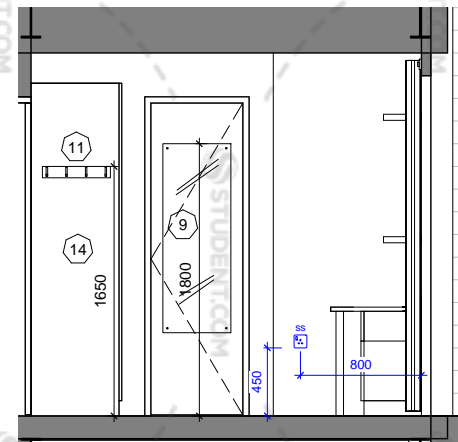

SB_11 - Elevation A

1 : 50

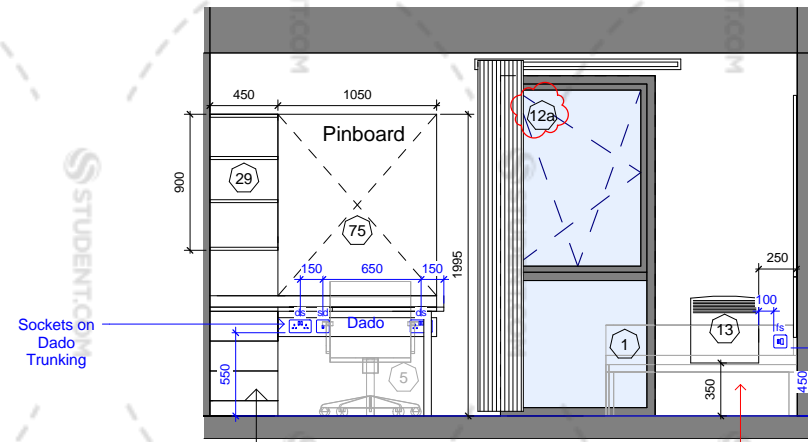


Drawer Unit

SB_11 - Elevation B


1 : 50

Socket to be installed to right hand side at all times to avoid back to back sockets.

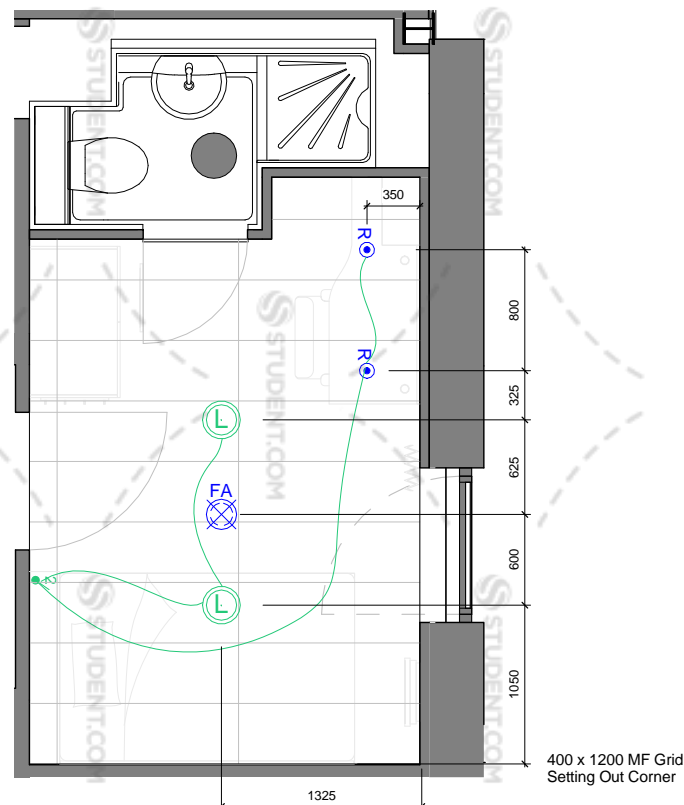


SB_11 - Reflected Ceiling Plan

1 : 50

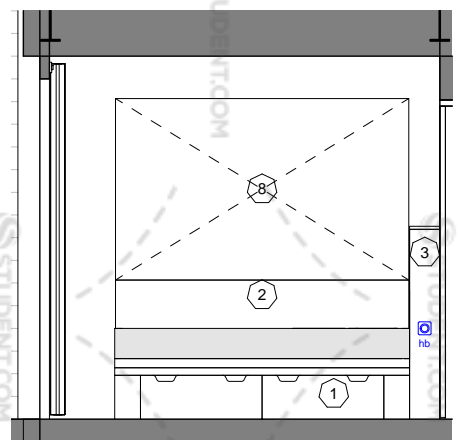


SB_11 - Elevation C

1 : 50

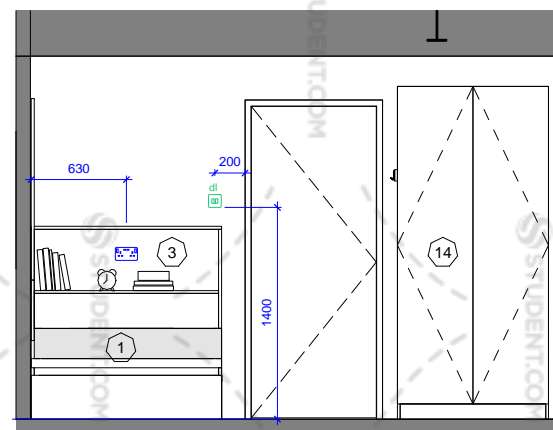

SB_11 - Elevation D

1 : 50

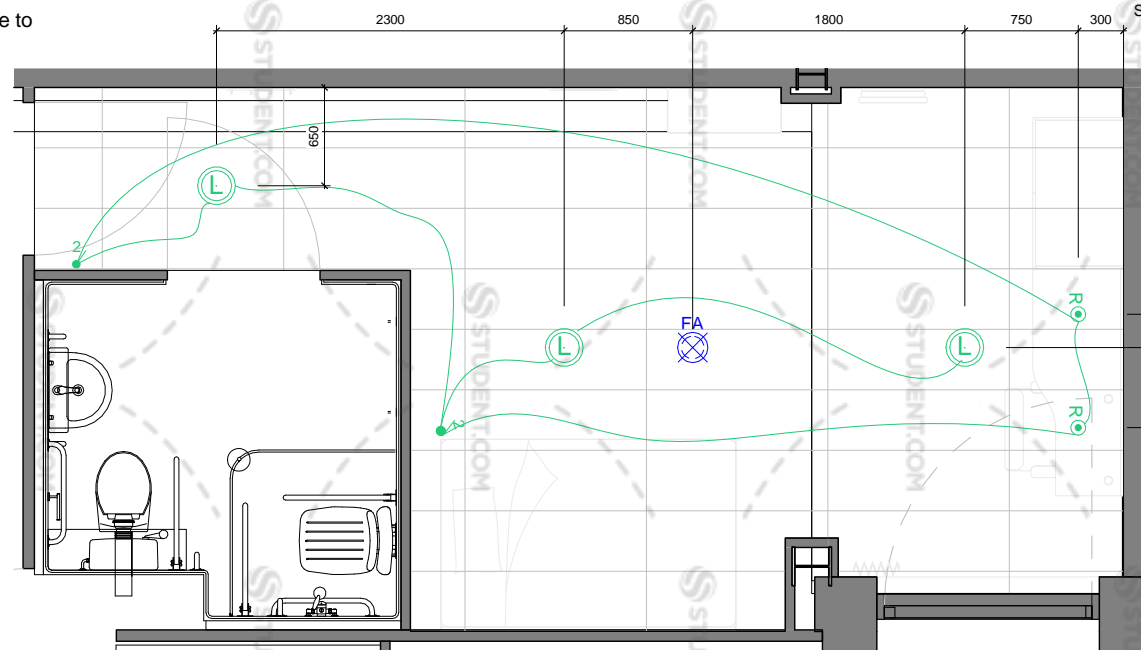

SB_12 - Reflected Ceiling Plan


1 : 50

No.	Description	Count
1	Cabin Bed	1
2	Long Side Wall Protector	1
3	Bed-head Shelf Storage Unit	1
4	Scalloped Desk with Drawer Unit Underneath	1
5	Operators Chair with Arms	1
7	Floor Mounted Bookcase	1
8	Pinboard (Above Bed)	1
9	Framed Mirror	1
11	4 Coat Hooks Mounted on Wall Plate	1
12a	Fire Retardant Curtains (Single) on RAL 9010 PVC Track	1
13	Heater to M&E Specification	1
14	Double Wardrobe - Refer to Matrix	1
16	Pinboard (Above Desk)	1

ELECTRICAL SYMBOL KEY


- Electrical sockets and lighting shown for coordination purposes only.
- Lighting to M&E Sub-contractors design to meet RDS lux levels.
- Please refer to M&E sub-contractors drawings for final positions.
- All drawings to be confirmed by Sub-contractor's before manufacture
- All Radiator positions to be confirmed by M&E Sub-contractor

CONSTRUCTION

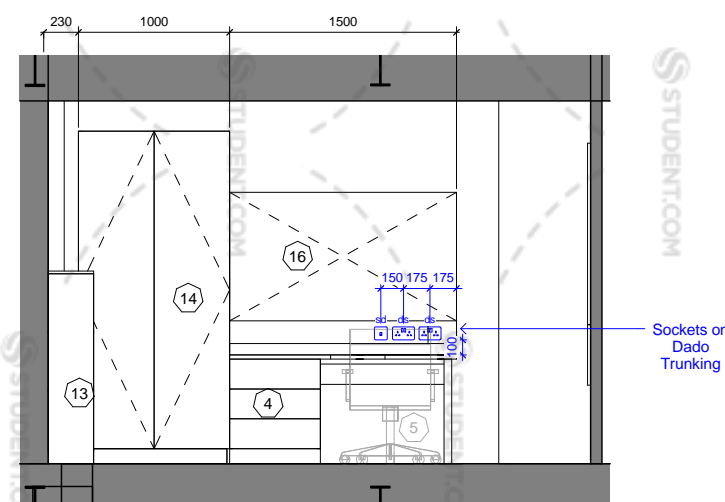

SB_12 - Elevation B

1 : 50

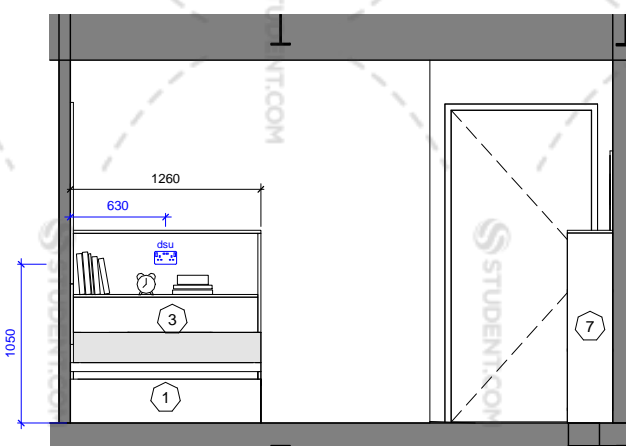

SB 12 - Elevation D

1 : 50

oea
oconnell east architects
63 Newton Street, Manchester, M1 1ET


dwg title: Study Bed Type 12

dwg title:	Study Bed Type 12		
job title:	Legge Street for Pochin		
scale:	1 : 50	@ A3	drawn: AP
date:	17/04/15	job no:	1511
dwg no:	1511_72_012		rev: L

SB_13 - Plan View


1 : 50

Wall framed out for electrics

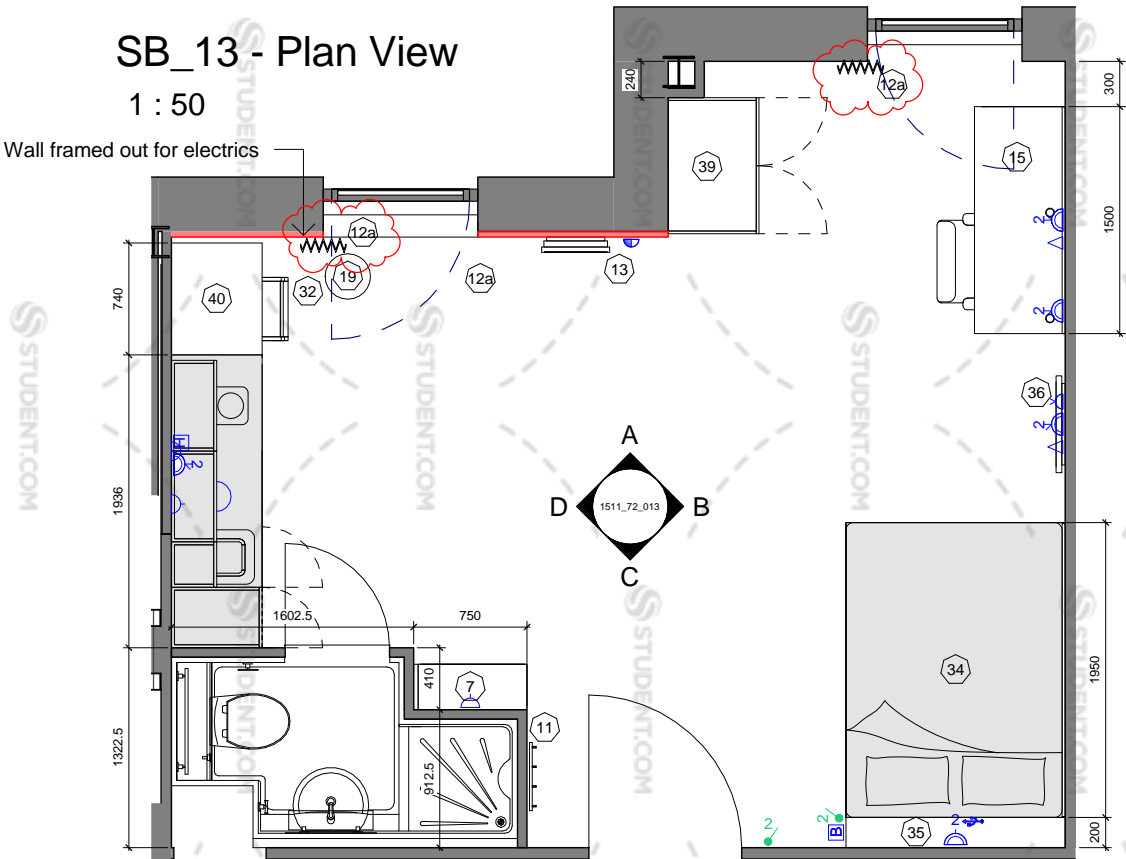

SB_13 - Reflected Ceiling Plan

1 : 50

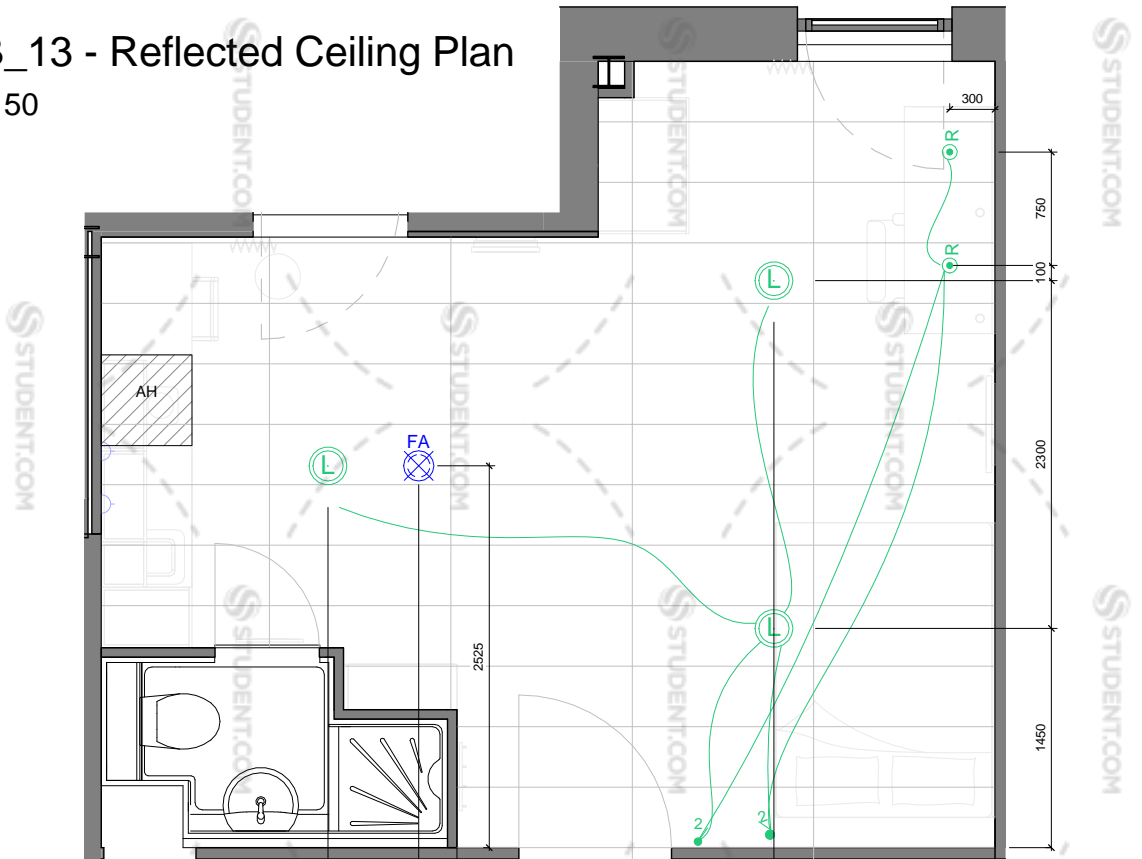

notes:

All dimensions are in millimetres unless stated otherwise. No dimensions to be scaled from drawings. All dimensions to be checked on site prior to manufacture.

Any discrepancies between drawings and site conditions are to be reported to the contract manager.

This drawing is to be read in conjunction with all relevant Structural Engineers and Mechanical & Electrical Engineers drawings and specification.

Copyright of this drawing and all the information it contains is the sole property of OEA and may not be reproduced or used for any purpose without the written approval of the authors

SB_13 - Schedule

No.	Description	Count
2	Long Side Wall Protector	1
5	Operators Chair with Arms	1
7	Floor Mounted Bookcase	1
8	Pinboard (Above Bed)	1
9	Framed Mirror	1
11	4 Coat Hooks Mounted on Wall Plate	1
12a	Fire Retardant Curtains (Single) on RAL 9010 PVC Track	1
13	Heater to M&E Specification	1
15	Desk with Drawer Unit Underneath	1
16	Pinboard (Above Desk)	1
19	General Waste Bin	1
26	Kitchenette (Including Appliances)	1
32	Breakfast Bar Stool	1
34	Cabin Bed	1
35	Bed-head Shelf Storage Unit	1
36	26" Smart TV on Wall Mounted Adjustable Bracket	1
39	Double Wardrobe - (900mm Width)	1
40	Breakfast Bar	1

ELECTRICAL SYMBOL KEY

ss	- Single Socket	tv	- TV Aerial
ds	- Double Socket	fs	- Fused Spur
dsu	- Double Socket with USB charging socket	ha	- Hob Angel Timer
sd	- Single Data (RJ45)	hb	- Heater Booster
dd	- Double Data (RJ45)	eb	- Extract Boost
sl	- Single Light Switch (1 gang)	L	- Bulkhead LED Light to M&E Spec.
dl	- Double Light Switch (2 gang)	R	- Recessed LED Light to M&E Spec.
cc	- Cooker wire connection	P	- PIR Sensor
is	- Cooker / Hob Isolation switch	FA	- Fire Alarm Sounder & Detector to M&E Spec.
		AH	- Access Hatch

- Electrical sockets and lighting shown for coordination purposes only.
- Lighting to M&E Sub-contractors design to meet RDS luv levels.
- Please refer to M&E sub-contractors drawings for final positions.
- All drawings to be confirmed by Sub-contractor's before manufacture
- All Bedhead designs to be confirmed by M&E Sub-contractor

CONSTRUCTION

Rev	Description	Date	By	Chk
M	Curtain type revised. Pod setting out note added.	15/09/16	AP	
L	Kitchenette & Bed head revised to Wessex details. Socket dimensions added & Access Hatch added to ceiling plan to match M&E. Construction Issue.	15/08/16	IW	AP
K	Ceiling grid and lighting loop altered to suit client comments.	02/08/16	IW	
J	Kitchen door revised to client comments.	04/07/16	AP	
H	Bedhead sockets added, FS added to match M&E. Relocation of socket behind book shelf	04/07/16	IW	AP
G	Relocation of Is, ss & mirror. Lighting loop added.	01/04/16	IW	AP
F	RCP revised to match M&E S.C. dwgs. Dimensions added. Wall framing out added.	15/01/16	GM	
E	Room layout revised	09/10/15	AP	
D	TENDER ISSUE	22/05/15	AP	
C	Electrical socket key added	18/05/15	AP	
B	Revised to suit Client's comments	14/05/15	AP	
A	Revised to suit Client's comments	11/05/15	AP	

oea

oconnell east architects
63 Newton Street, Manchester, M1 1ET

t: 0161 839 9380 f: 0161 833 1368


dwg title:	Study Bed Type 13
job title:	Legge Street for Pochin
scale:	1 : 50 @ A3
date:	27/04/15
dwg no:	1511_72_013
drawn:	AP
job no:	1511
rev:	M

© OConnell East Architects - 2016

SB_13 - Elevation A


1 : 50

Socket to be installed to right hand side at all times to avoid back to back sockets.

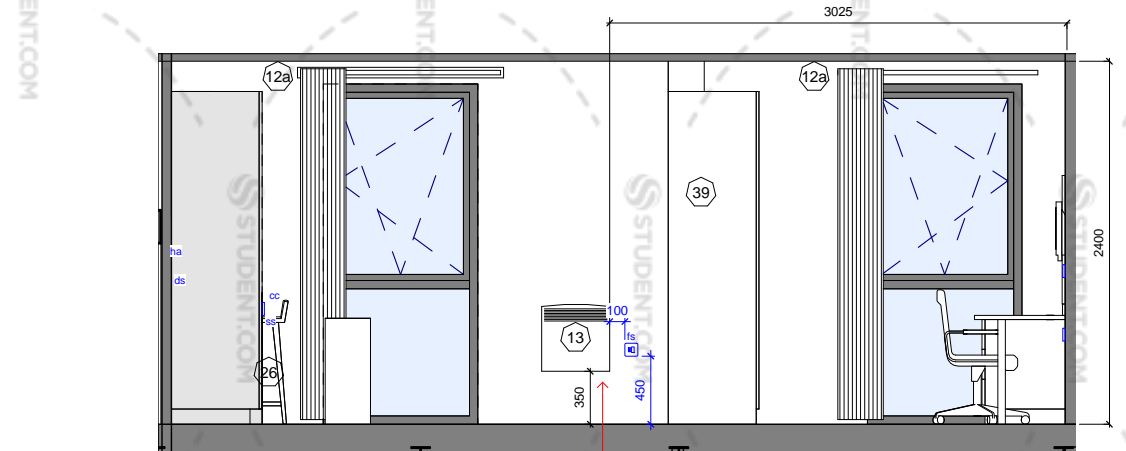


SB_13 - Elevation C

1 : 50

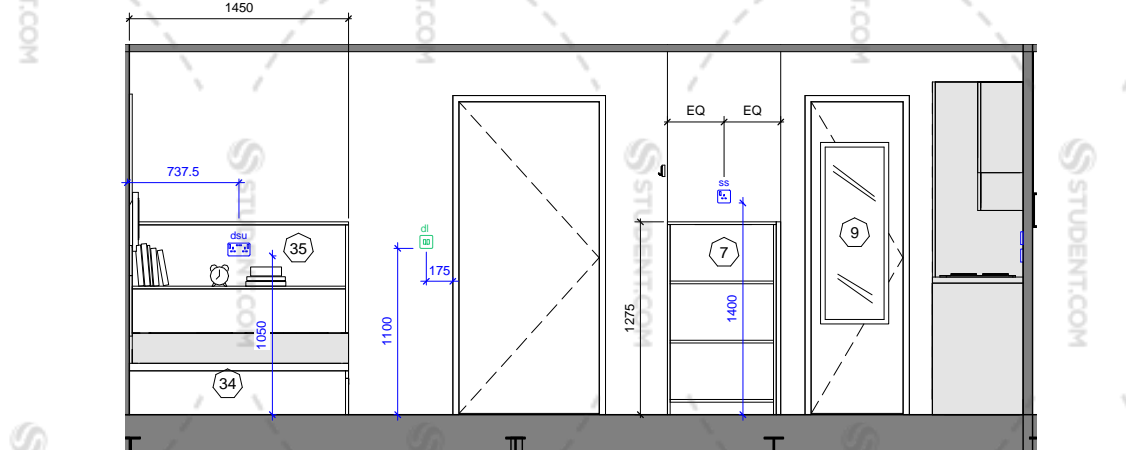


SB_13 - Elevation B


1 : 50

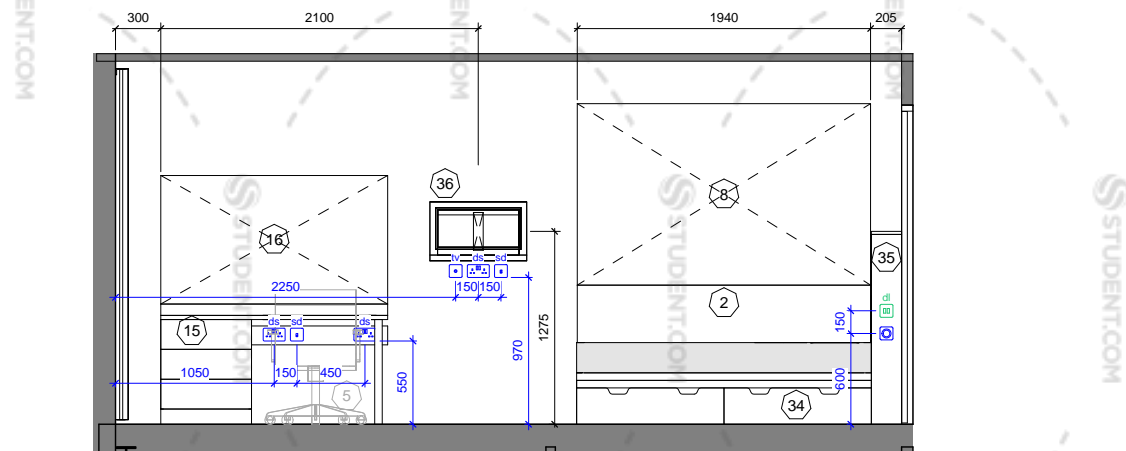


SB_13 - Elevation D

1 : 50

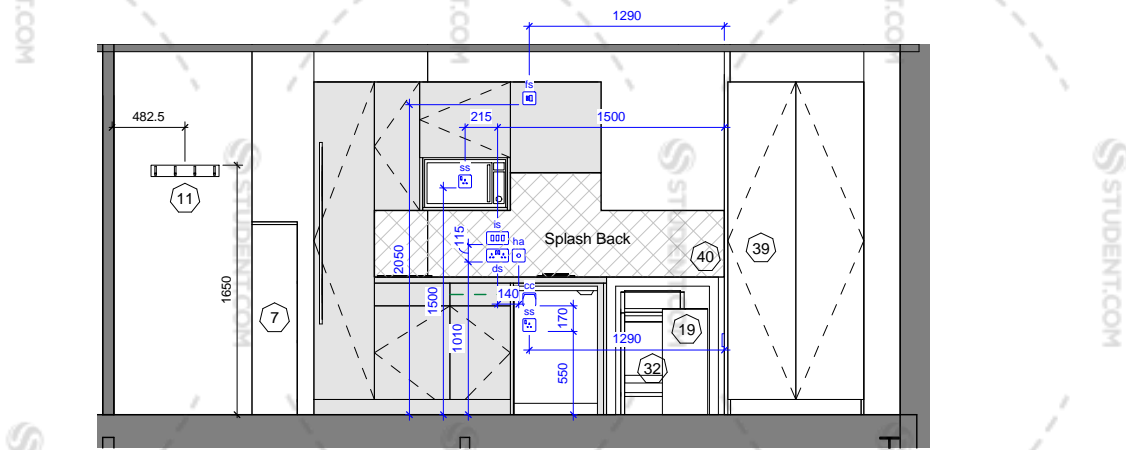

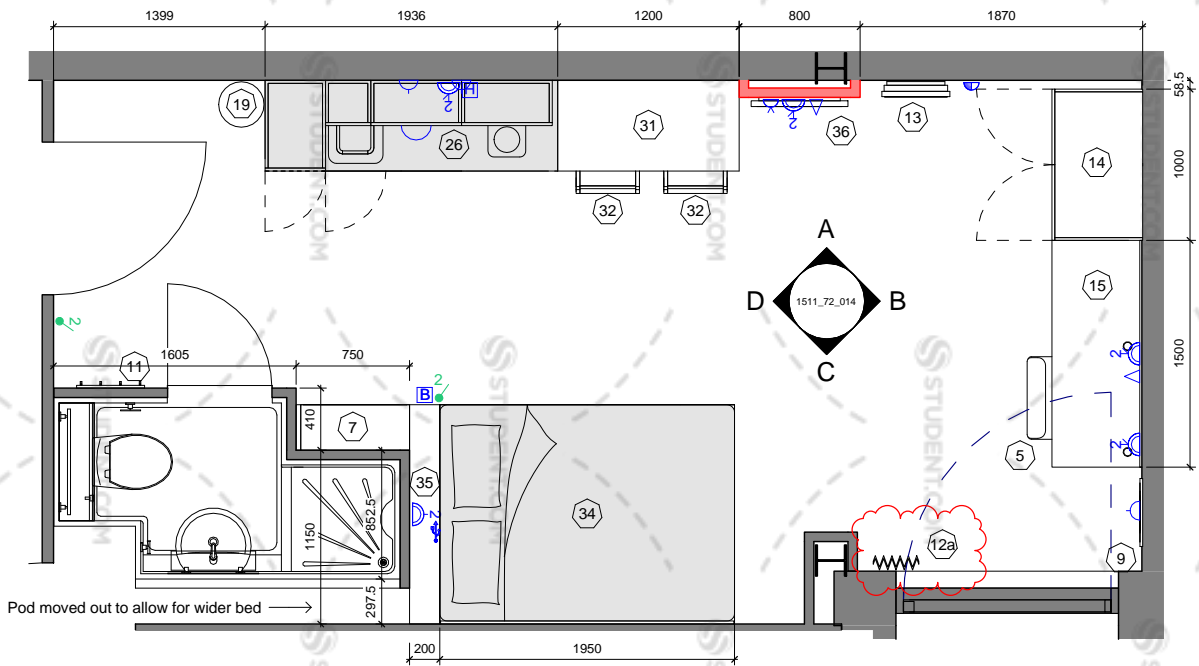

SB_14 - Plan View
1 : 50

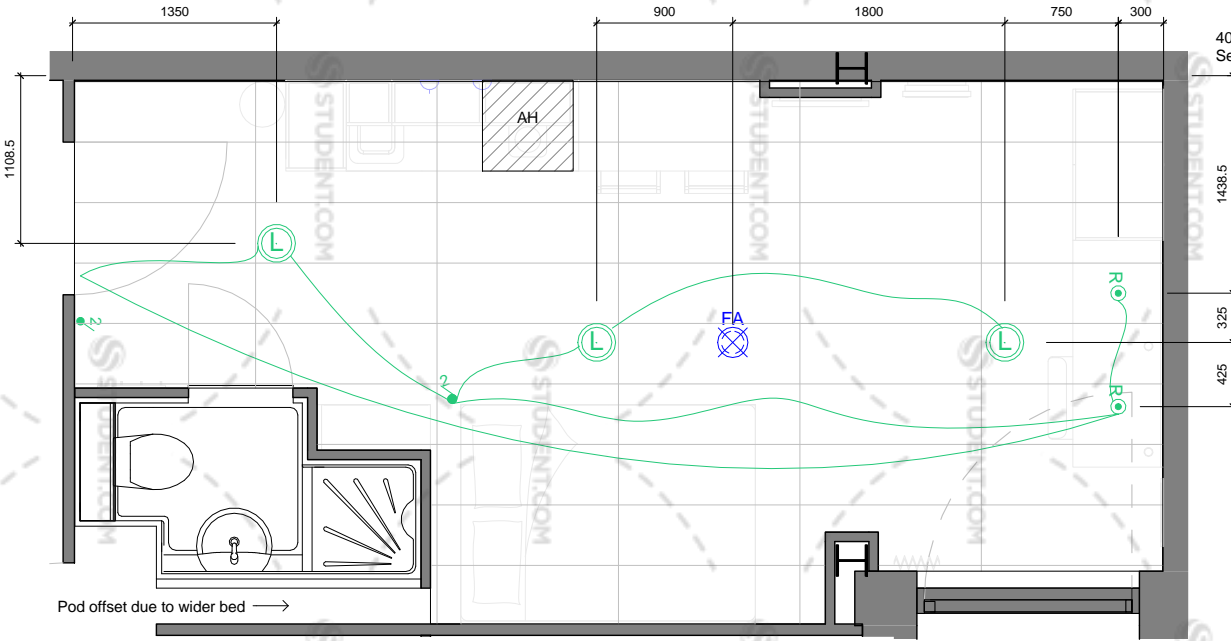

SB_14 - Reflected Ceiling Plan
1 : 50

notes:

All dimensions are in millimetres unless stated otherwise. No dimensions to be scaled from drawings. All dimensions to be checked on site prior to manufacture.

Any discrepancies between drawings and site conditions are to be reported to the contract manager.

This drawing is to be read in conjunction with all relevant Structural Engineers and Mechanical & Electrical Engineers drawings and specification.

Copyright of this drawing and all the information it contains is the sole property of OEA and may not be reproduced or used for any purpose without the written approval of the authors

SB_14 - Schedule		
No.	Description	Count
2	Long Side Wall Protector	1
5	Operators Chair with Arms	1
7	Floor Mounted Bookcase	1
8	Pinboard (Above Bed)	1
9	Framed Mirror	1
11	4 Coat Hooks Mounted on Wall Plate	1
12a	Fire Retardant Curtains (Single) on RAL 9010 PVC Track	1
13	Heater to M&E Specification	1
14	Double Wardrobe - Refer to Matrix	1
15	Desk with Drawer Unit Underneath	1
16	Pinboard (Above Desk)	1
19	General Waste Bin	1
26	Kitchenette (Including Appliances)	1
31	Breakfast Bar	1
32	Breakfast Bar Stool	2
34	Cabin Bed	1
35	Bed-head Shelf Storage Unit	1
36	26" Smart TV on Wall Mounted Adjustable Bracket	1


- Walls to be framed out for electrics to remove penetrations from air seal line
- ELECTRICAL SYMBOL KEY**
- | | | | |
|-----|--|----|--|
| ss | - Single Socket | tv | - TV Aerial |
| ds | - Double Socket | fs | - Fused Spur |
| dsu | - Double Socket with USB charging socket | ha | - Hob Angel Timer |
| sd | - Single Data (RJ45) | hb | - Heater Booster |
| dd | - Double Data (RJ45) | eb | - Extract Boost |
| sl | - Single Light Switch (1 gang) | L | - Bulkhead LED Light to M&E Spec. |
| dl | - Double Light Switch (2 gang) | R | - Recessed LED Light to M&E Spec. |
| cc | - Cooker wire connection | P | - PIR Sensor |
| is | - Cooker / Hob isolation switch | FA | - Fire Alarm Sounder & Detector to M&E Spec. |
| | | AH | - Access Hatch |
- Electrical sockets and lighting shown for coordination purposes only.
• Lighting to M&E Sub-contractors design to meet RDS lux levels.
• Please refer to M&E sub-contractors drawings for final positions.
• All drawings to be confirmed by Sub-contractors before manufacture
• M&E Sub-contractors to be confirmed by M&E Sub-contractor
- dwg status**

CONSTRUCTION


Rev	Description	Date	By	Chk
K	Curtain type revised. Pod setting out note added.	15/09/16	AP	
J	Access Hatch added to ceiling plan to match M&E, Furniture revised to Wessex drawings. Construction Issue.	15/08/16	IW	AP
H	Ceiling grid and lighting loop altered to suit client comments.	02/08/16	IW	AP
G	Bedhead sockets added, FS added to match M&E	04/07/16	IW	AP
F	Lightswitch moved and splashback added. Lighting loop added.	01/04/16	IW	AP
E	RCP revised to match M&E S.C. dwgs. Dimensions added. Layout revised to suit change in room size.	15/01/16	GM	
D	General revision.	28/09/15	AP	
C	TENDER ISSUE	22/05/15	AP	
B	Electrical socket key added	18/05/15	AP	
A	Revised to suit Client's comments	14/05/15	AP	

oea
oconnell east architects
63 Newton Street, Manchester, M1 1ET
t: 0161 839 9380 f: 0161 833 1368


dwg title:	Study Bed Type 14		
job title:	Legge Street for Pochin		
scale:	1 : 50 @ A3	drawn:	AP
date:	11/05/15	job no:	1511
dwg no:	1511_72_014	rev:	K

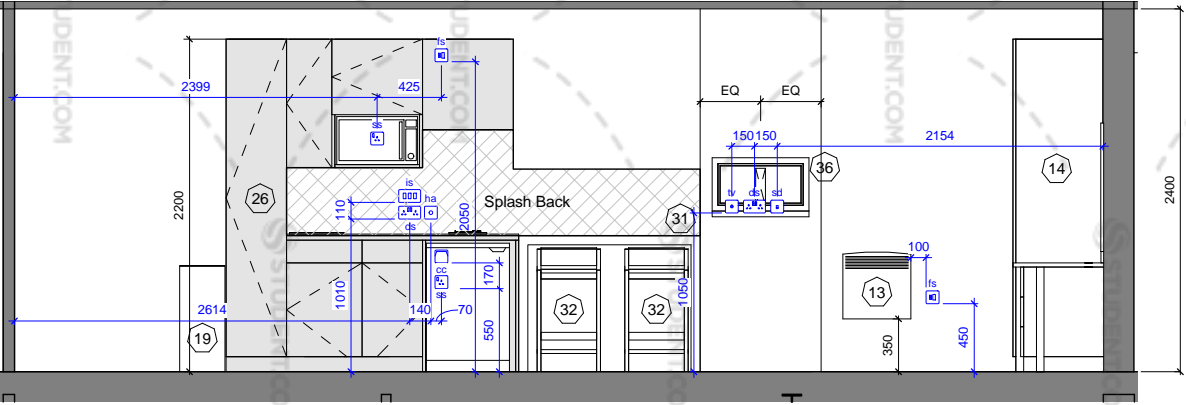


SB_14 - Elevation A
1 : 50

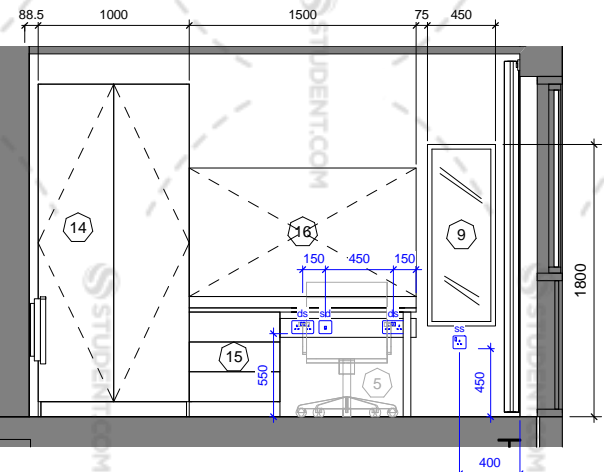


SB_14 - Elevation B
1 : 50

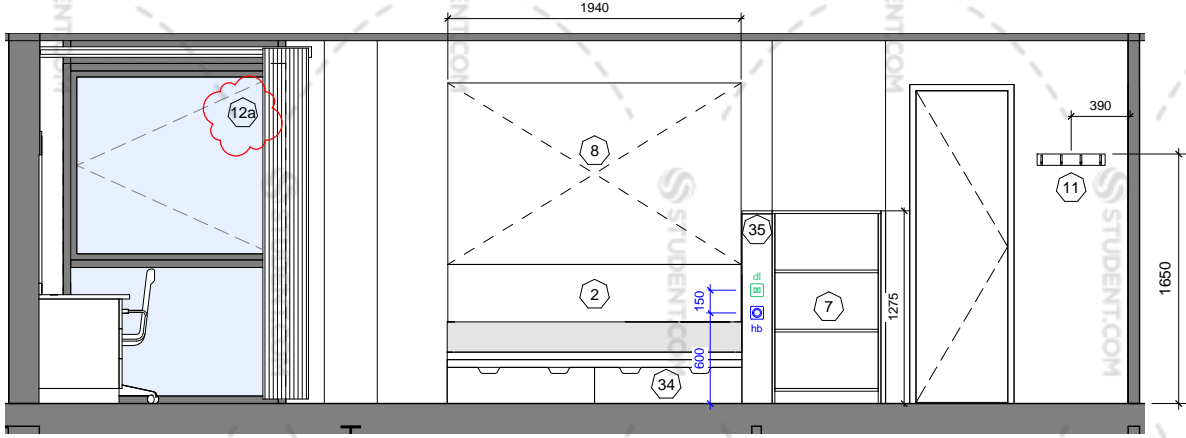

SB_14 - Elevation C
1 : 50

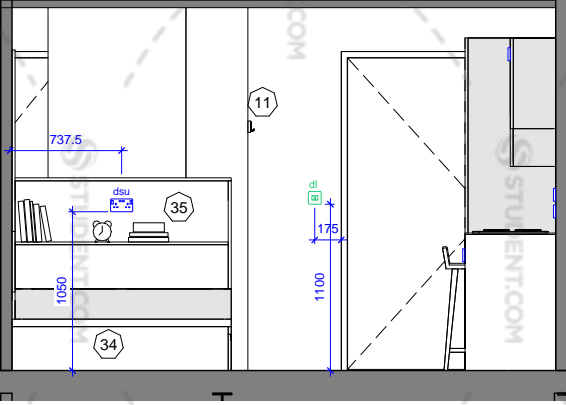


SB_14 - Elevation D
1 : 50

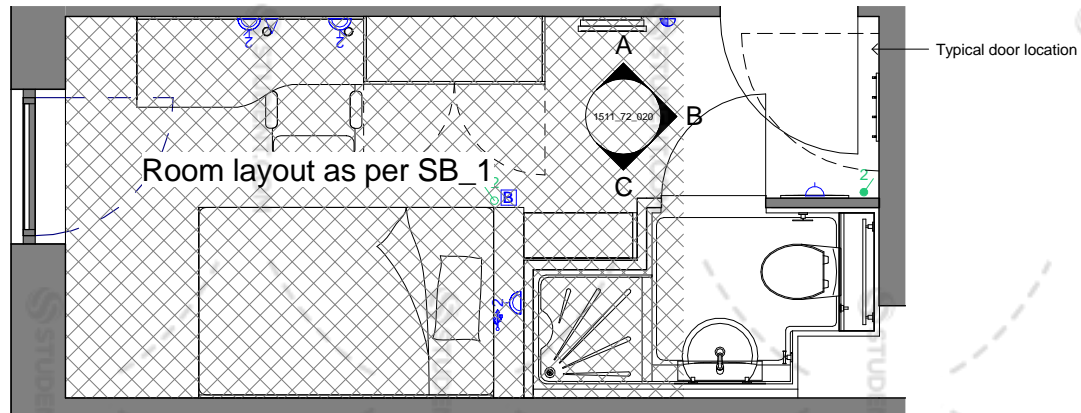

SB_1 - Plan View (Door Variant)


1 : 50

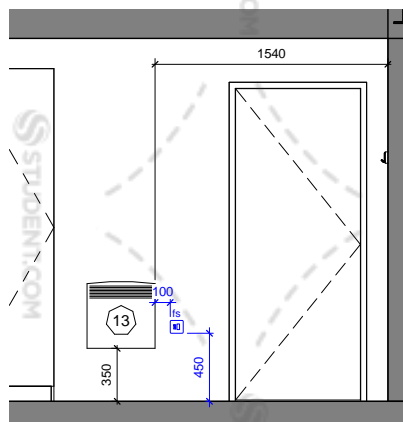

Radiator setting out as per typical SB_1


Elevation A

1 : 50

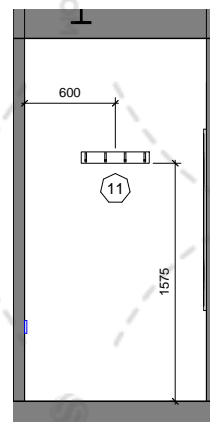

Elevations B

1 : 50

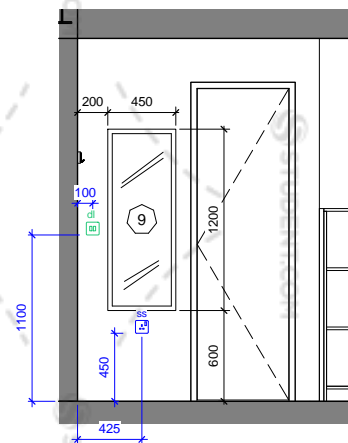

Elevation C

1 : 50

notes:

All dimensions are in millimetres unless stated otherwise. No dimensions to be scaled from drawings. All dimensions to be checked on site prior to manufacture.

Any discrepancies between drawings and site conditions are to be reported to the contract manager.

This drawing is to be read in conjunction with all relevant Structural Engineers and Mechanical & Electrical Engineers drawings and specification.

Drawing to be used in conjunction with SB_1 Room Type Drawing.

Refer to 1511_72_001

dwg status:

CONSTRUCTION

Rev	Description	Date	By	Chk

oea

oconnell east architects
63 Newton Street, Manchester, M1 1ET


t: 0161 839 9380 f: 0161 833 1638

dwg title: Study Bed Type 1 (Door Variant)


job title: Legge Street
for Pochin

scale: 1 : 50 @ A4 drawn: AP
date: 22/09/16 job no: 1511


dwg no: 1511_72_020 rev: *

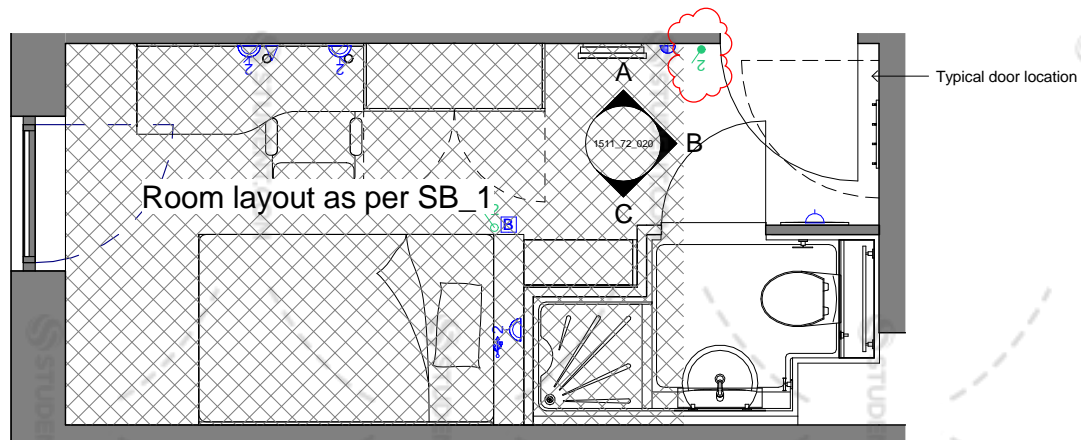


SB_1 - Plan View (Door Variant)
1 : 50

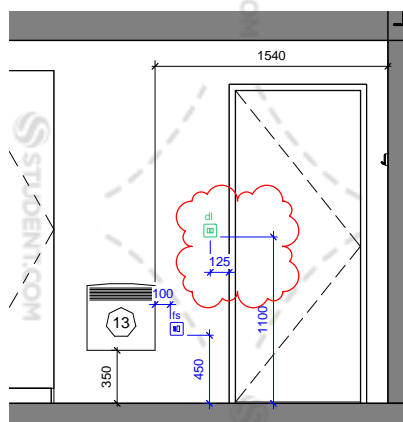

Elevation A
1 : 50

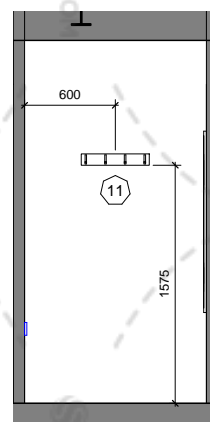

Elevations B
1 : 50

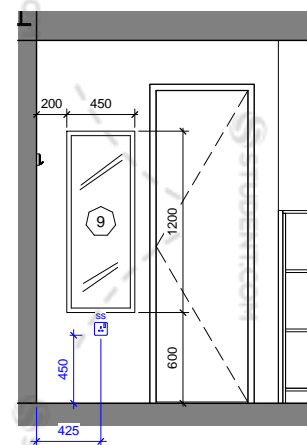

Elevation C
1 : 50

notes:

All dimensions are in millimetres unless stated otherwise. No dimensions to be scaled from drawings. All dimensions to be checked on site prior to manufacture.

Any discrepancies between drawings and site conditions are to be reported to the contract manager.

This drawing is to be read in conjunction with all relevant Structural Engineers and Mechanical & Electrical Engineers drawings and specification.

Drawing to be used in conjunction with SB_1 Room Type Drawing.

Refer to 1511_72_001

dwg status:

CONSTRUCTION

Rev	Description	Date	By	Chk
A	Lighting switch moved as per client comments. Drawing title revised	24.10.16	AP	

oconnell east architects
63 Newton Street, Manchester, M1 1ET

t: 0161 839 9380 f: 0161 833 1638

dwg title: Study Bed Type 1b (Door Variant)

job title:	Legge Street for Pochin			
scale:	1 : 50	@ A4	drawn:	AP
date:	22/09/16		job no:	1511
dwg no:	1511_72_020		rev:	A

notes:

All dimensions are in millimetres unless stated otherwise. No dimensions to be scaled from drawings. All dimensions to be checked on site prior to manufacture.

Any discrepancies between drawings and site conditions are to be reported to the contract manager.

This drawing is to be read in conjunction with all relevant Structural Engineers and Mechanical & Electrical Engineers drawings and specification.

Copyright of this drawing and all the information it contains is the sole property of OEA and may not be reproduced or used for any purpose without the written approval of the authors

Drawing to be used in conjunction with SB_1 Room Type Drawing.

Refer to 1511_72_001

dwg status:

CONSTRUCTION

Rev	Description	Date	By	Chk
A	Mirror and socket moved to pod wall at contractors request.	23.09.16	AP	

oea

oconnell east architects
63 Newton Street, Manchester, M1 1ET

t: 0161 839 9380 f: 0161 833 1368

dwg title: Study Bed Type 1 (Near Bracing)


job title: Legge Street
for Pochin

scale: As indicated @ A3 drawn: AP

date: 23/09/16 job no: 1511


dwg no: 1511_72_021 rev: A

© OConnell East Architects - 2016

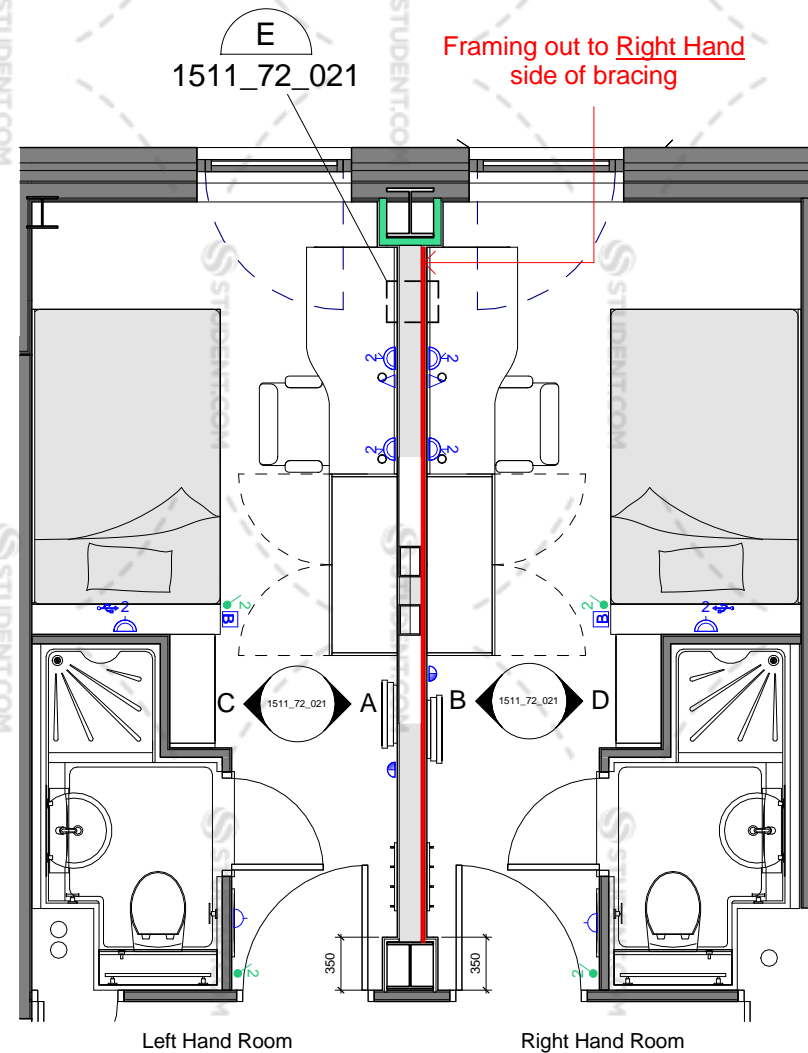


SB_1 - Rooms Next to Bracing
1 : 50

Wall Type
RCP 002 Mod 146
P5

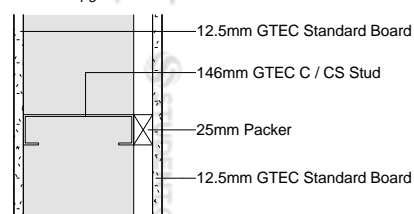


Refer to 22 Series for Details


Wall Detail E
1 : 10

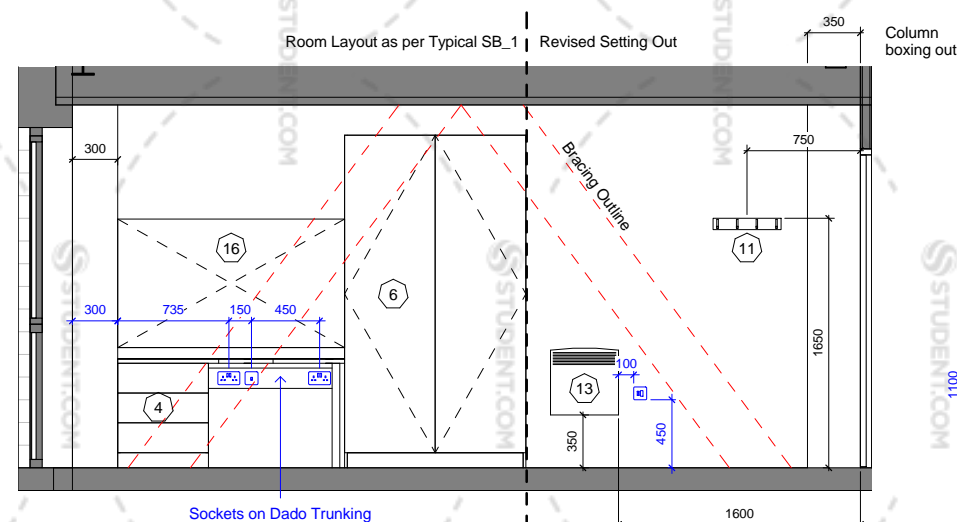


Elevation A - Left Hand Room
1 : 50

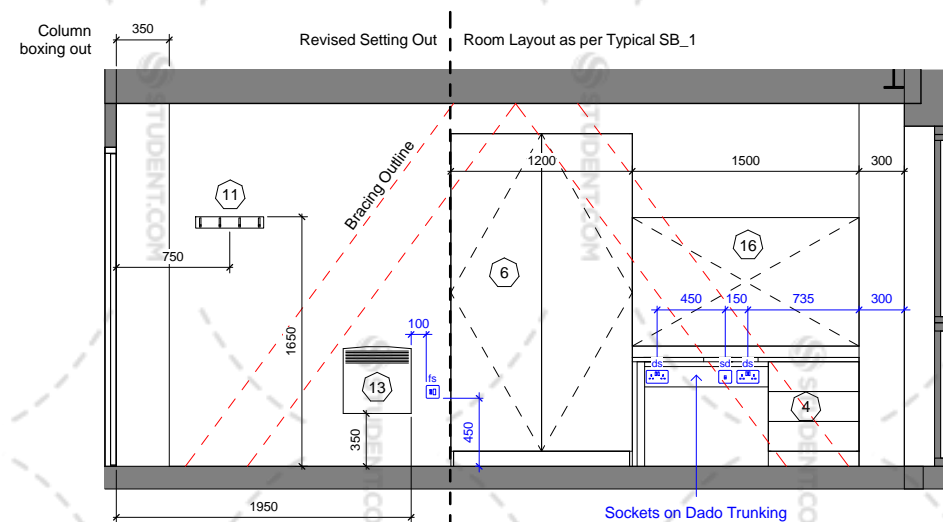

Elevation B - Right Hand Room
1 : 50

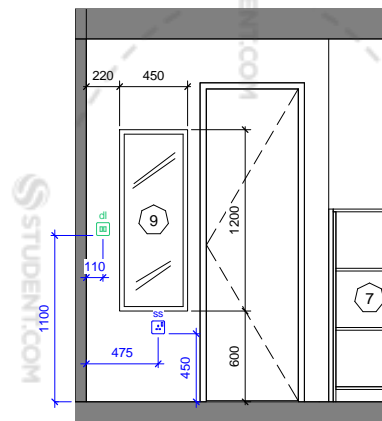

Elevation C - LH Room
1 : 50

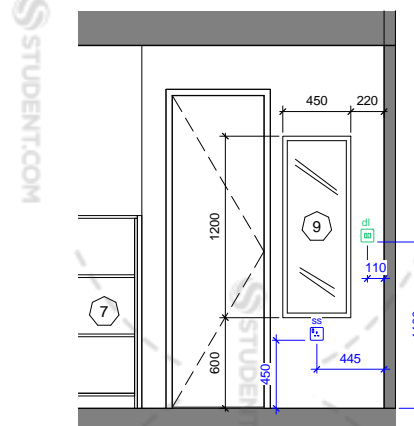

Elevation D - RH Room
1 : 50